

The Ratcliff Architects

6117 GROVE ST. OAKLAND, CA. 94609
PHONE: (415) 852-1972

DRAWN BY: *[Signature]* CHECKED BY: *[Signature]*
PROJECT DIRECTOR: *[Signature]*

ASSOCIATED ARCHITECTS:
Ishimaru Design Group
468 25TH ST. OAKLAND, CA 94612 (415) 839-8313

STRUCTURAL ENGINEERS:
H. J. Degenkolb Associates
350 SANSOME ST., SUITE 500 SAN FRANCISCO, CA 94104 (415) 392-6952

ASSOCIATED STRUCTURAL ENGINEERS:
Jordan-Avent & Associates

MECHANICAL ENGINEERS:
JYA Consulting Engineers
50 BRANNAN ST. SAN FRANCISCO, CA 94107 (415) 543-8411

ASSOCIATED MECHANICAL ENGINEERS:
Pyramid Designs



ELECTRICAL ENGINEERS:
Ray I. Juachon & Associates
65 SHERIDAN ST. SAN FRANCISCO, CA 94103 (415) 552-4832

LIGHTING:
Marlene Lee Lighting Design Consulting Engineers
573 MISSION ST. SAN FRANCISCO, CA 94105 (415) 546-7885

18 AUG 1982 APPEN JM #1

Henry J. Kaiser Convention Center
10-10TH ST. OAKLAND, CA 94607

SITE PLAN

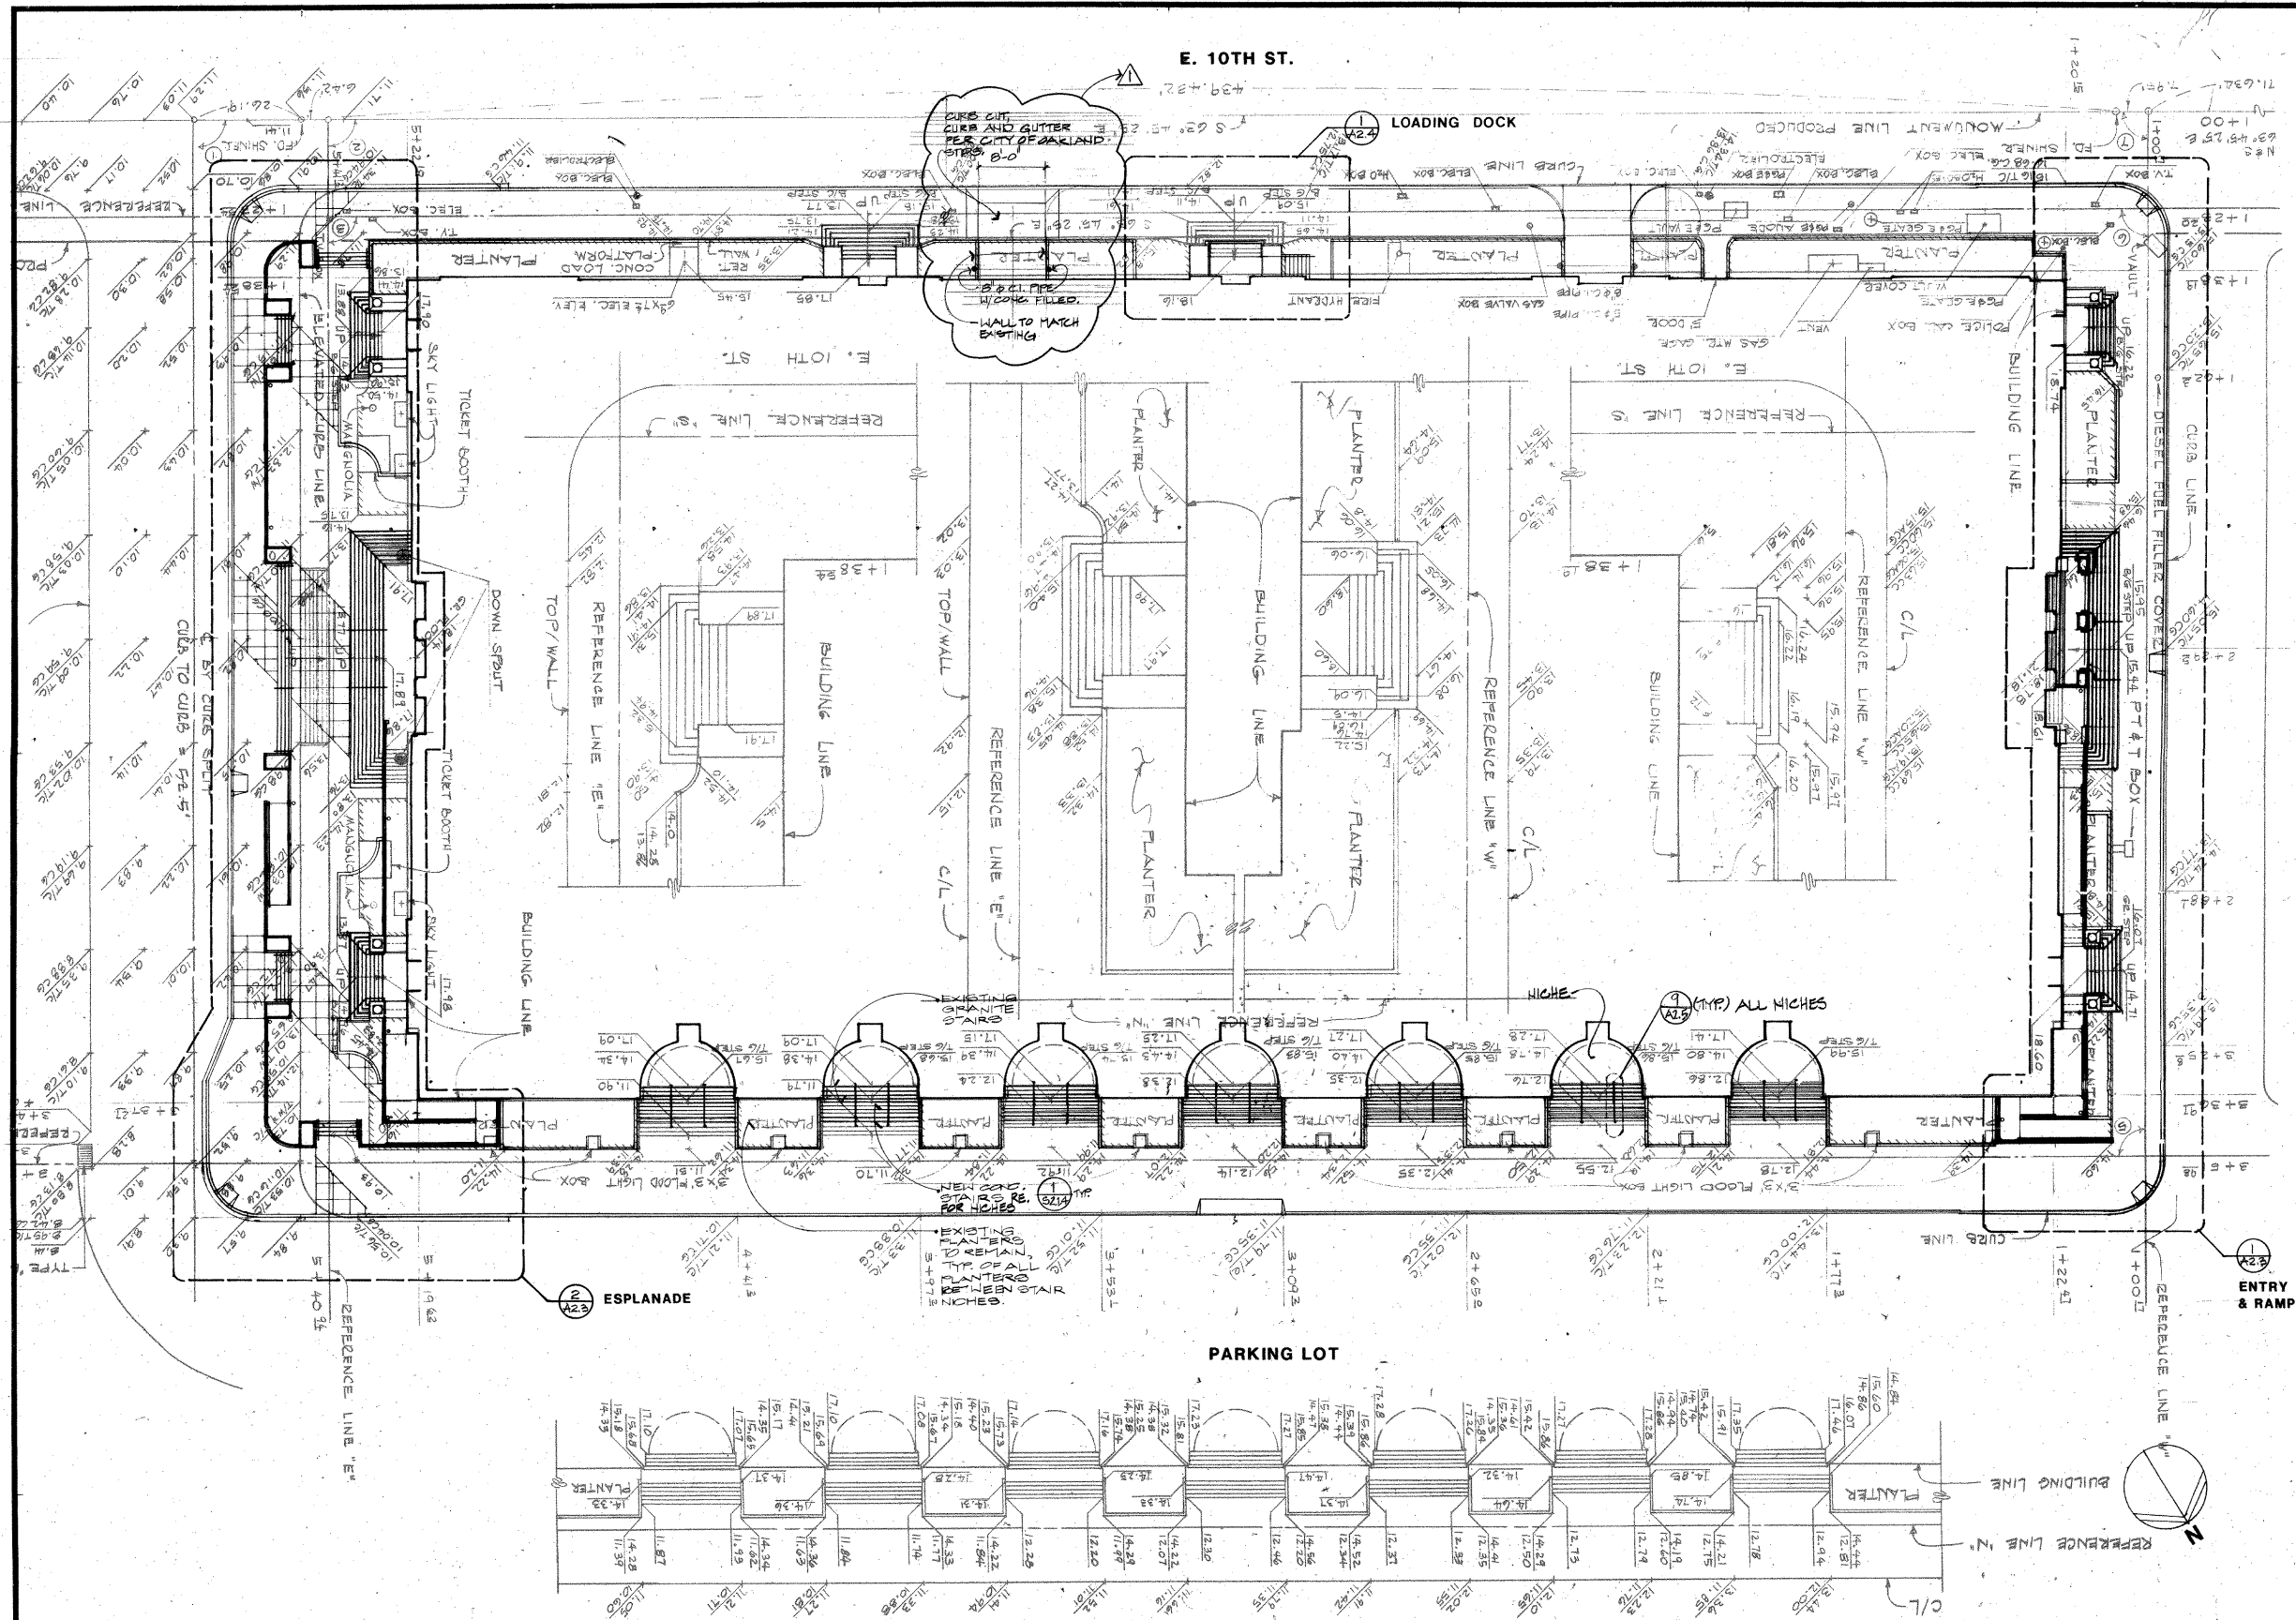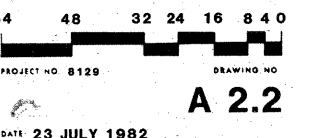

6117 GROVE ST. OAKLAND, CA. 94608
PHONE: (415) 852 1972

DRAWN CHECKED
PRINTED Burns Caldwell PROJECT DIRECTOR
BURNS CADDWALDER, C.2340

STRUCTURAL ENGINEERS
H. J. Degenkolb Associates
350 SANSOME ST., SUITE 500
SAN FRANCISCO, CA 94104 (415) 392-8952

MECHANICAL ENGINEERS
JYA Consulting Engineers
50 BRANNAN ST.
SAN FRANCISCO, CA 94107 (415) 543-8411

ELECTRICAL ENGINEERS
Ray I. Juachon & Associates
65 SHERIDAN ST.
SAN FRANCISCO, CA 94103 (415) 552-4832

LIGHTING

**Marlene Lee Lighting Design
Consulting Engineers**

573 MISSION ST.
SAN FRANCISCO, CA 94105 (415) 546-7885

10-10TH ST.
OAKLAND, CA 94607

64 48 32 24 16 8 4 0

PROJECT NO. 8129

DRAWING NO. **A3.1**

DATE 23 JULY 1982



1. IN AREAS TO RECEIVE (4) CONC. SLAB:
- A. DEMOLISH ALL NON-CONCRETE, NON-STRUCTURAL FENCES AND PARTITIONS. DO NOT REPLACE, UNLESS NOTED ON DRAWINGS.
 - B. SALVAGE ALL EQUIPMENT, FURNISHINGS OR OTHER ITEMS MOUNTED OR STORED IN THE BASEMENT, UNLESS NOTED OTHERWISE.

The Ratcliff Architects

4117 GROVE ST. OAKLAND, CA 94609
PHONE: (415) 852-1972

DRAWN: *B. H. H. H.* CHECKED: *B. H. H. H.*
PRINCIPAL: *B. H. H. H.* PROJECT DIRECTOR: *B. H. H. H.*

ASSOCIATED ARCHITECTS:
Ishimaru Design Group
468 25TH ST.
OAKLAND, CA 94612 (415) 839-8313

STRUCTURAL ENGINEERS:
H. J. Degenkolb Associates
350 SANSOME ST., SUITE 500
SAN FRANCISCO, CA 94104 (415) 392-6952

ASSOCIATED STRUCTURAL ENGINEERS:
Jordan-Avent & Associates

MECHANICAL ENGINEERS:
JYA Consulting Engineers
50 BRANNAN ST.
SAN FRANCISCO, CA 94107 (415) 543-8411

 
ASSOCIATED MECHANICAL ENGINEERS:
Pyramid Designs

ELECTRICAL ENGINEERS:
Ray I. Juachon & Associates
65 SHERIDAN ST.
SAN FRANCISCO, CA 94103 (415) 552-4832

LIGHTING:
Marlene Lee Lighting Design Consulting Engineers
573 MISSION ST.
SAN FRANCISCO, CA 94105 (415) 546-7885

Henry J. Kaiser
Convention Center
10-10TH ST.
OAKLAND, CA 94607


FIRST FLOOR KEY PLAN



PROJECT NO. 8129 DRAWING NO.

A3.2

DATE 23 JULY 1982

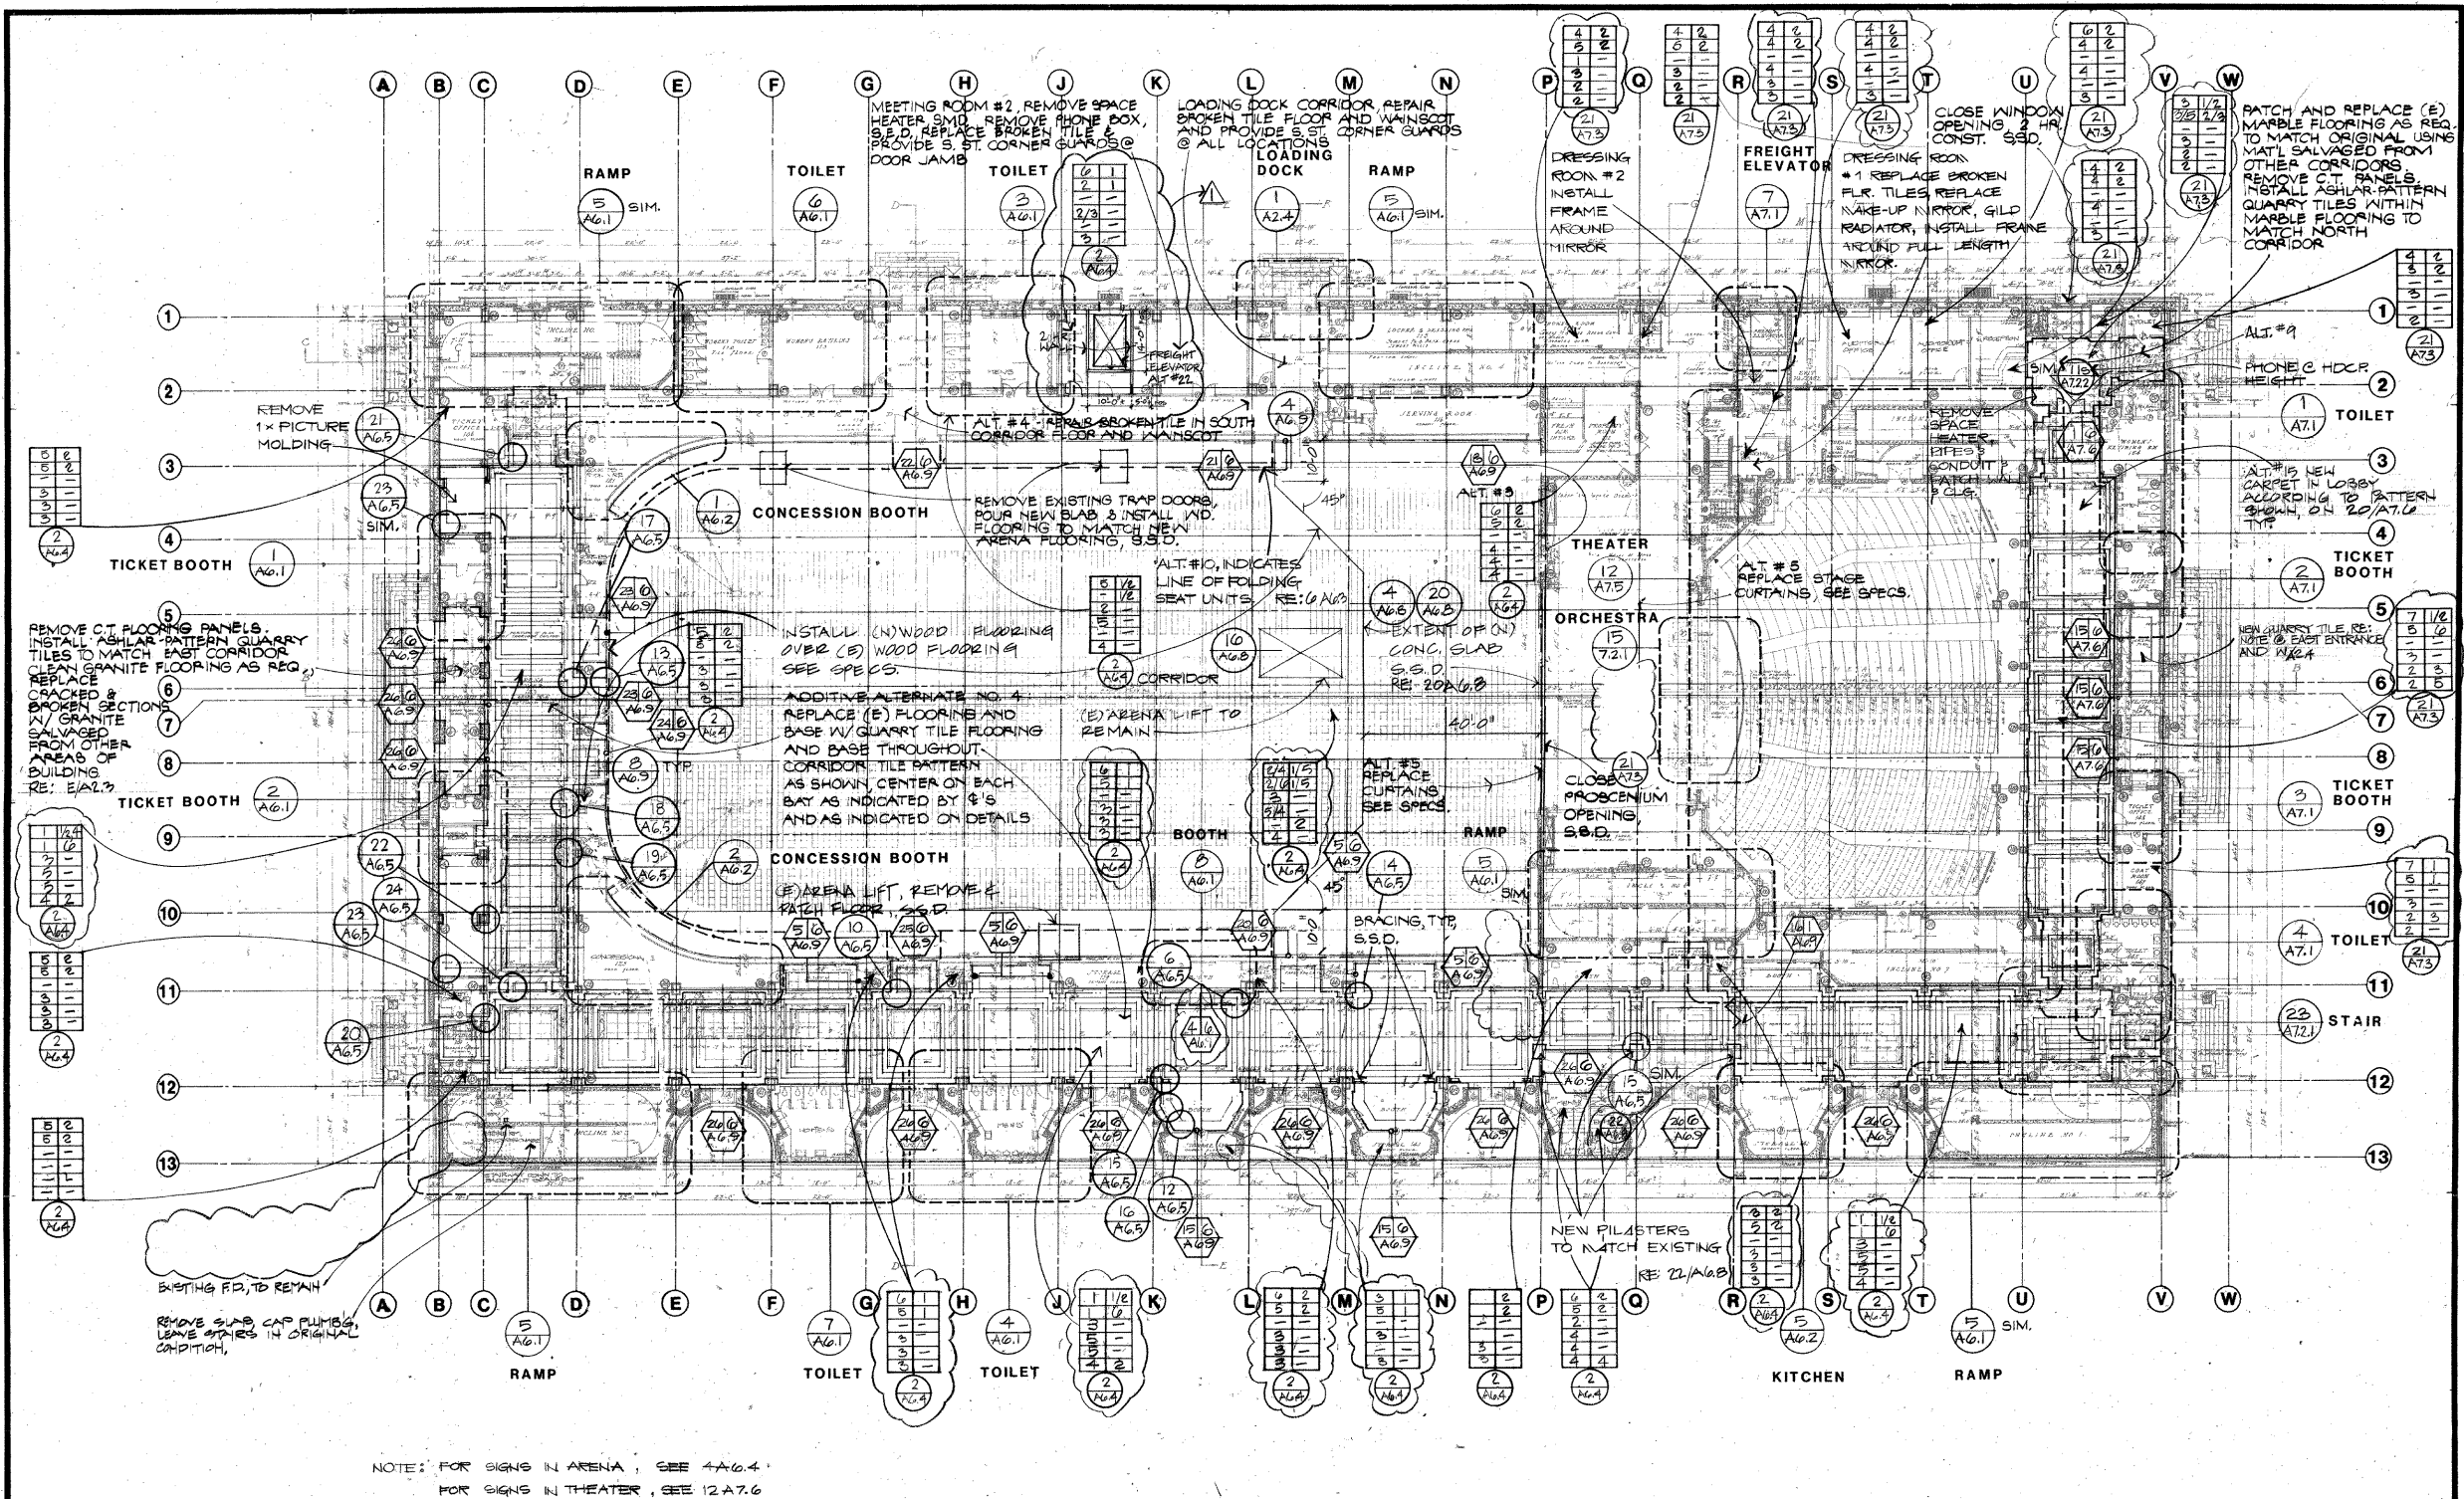

LIGHTING

**Marlene Lee Lighting Design
Consulting Engineers**

573 MISSION ST.
SAN FRANCISCO, CA 94105 (415) 546-7885

DATE 23 JULY 1982

[illegible]

The Ratcliff Architects

6117 GROVE ST. OAKLAND, CA 94609
PHONE: (415) 852-1973

DRAWN: *Paul Lee* CHECKED: *John Ratcliff*
PRINTED: *John Ratcliff* DIRECTOR

ASSOCIATED ARCHITECTS:
Ishimaru Design Group
468 25TH ST.
OAKLAND, CA 94612 (415) 838-8313

STRUCTURAL ENGINEERS:
H. J. Degenkolb Associates
350 SANSOME ST., SUITE 500
SAN FRANCISCO, CA 94104 (415) 392-6952

ASSOCIATED STRUCTURAL ENGINEERS:
Jordan-Avent & Associates

MECHANICAL ENGINEERS:
JYA Consulting Engineers
50 BRANNAN ST.
SAN FRANCISCO, CA 94107 (415) 543-8411

ASSOCIATED MECHANICAL ENGINEERS:
Pyramid Designs

ELECTRICAL ENGINEERS:
Ray I. Juachon & Associates
65 SHERIDAN ST.
SAN FRANCISCO, CA 94103 (415) 552-4832

LIGHTING:
Marlene Lee Lighting Design Consulting Engineers
573 MISSION ST.
SAN FRANCISCO, CA 94105 (415) 546-7885

18 AUG. 1982 ADDENDUM #1

Henry J. Kaiser Convention Center
10-10TH ST.
OAKLAND, CA 94607


THIRD FLOOR PLAN

64 48 32 24 16 8 4 0

PROJECT NO. 8129 DRAWING NO.

A3.4

DATE: 23 JULY 1982

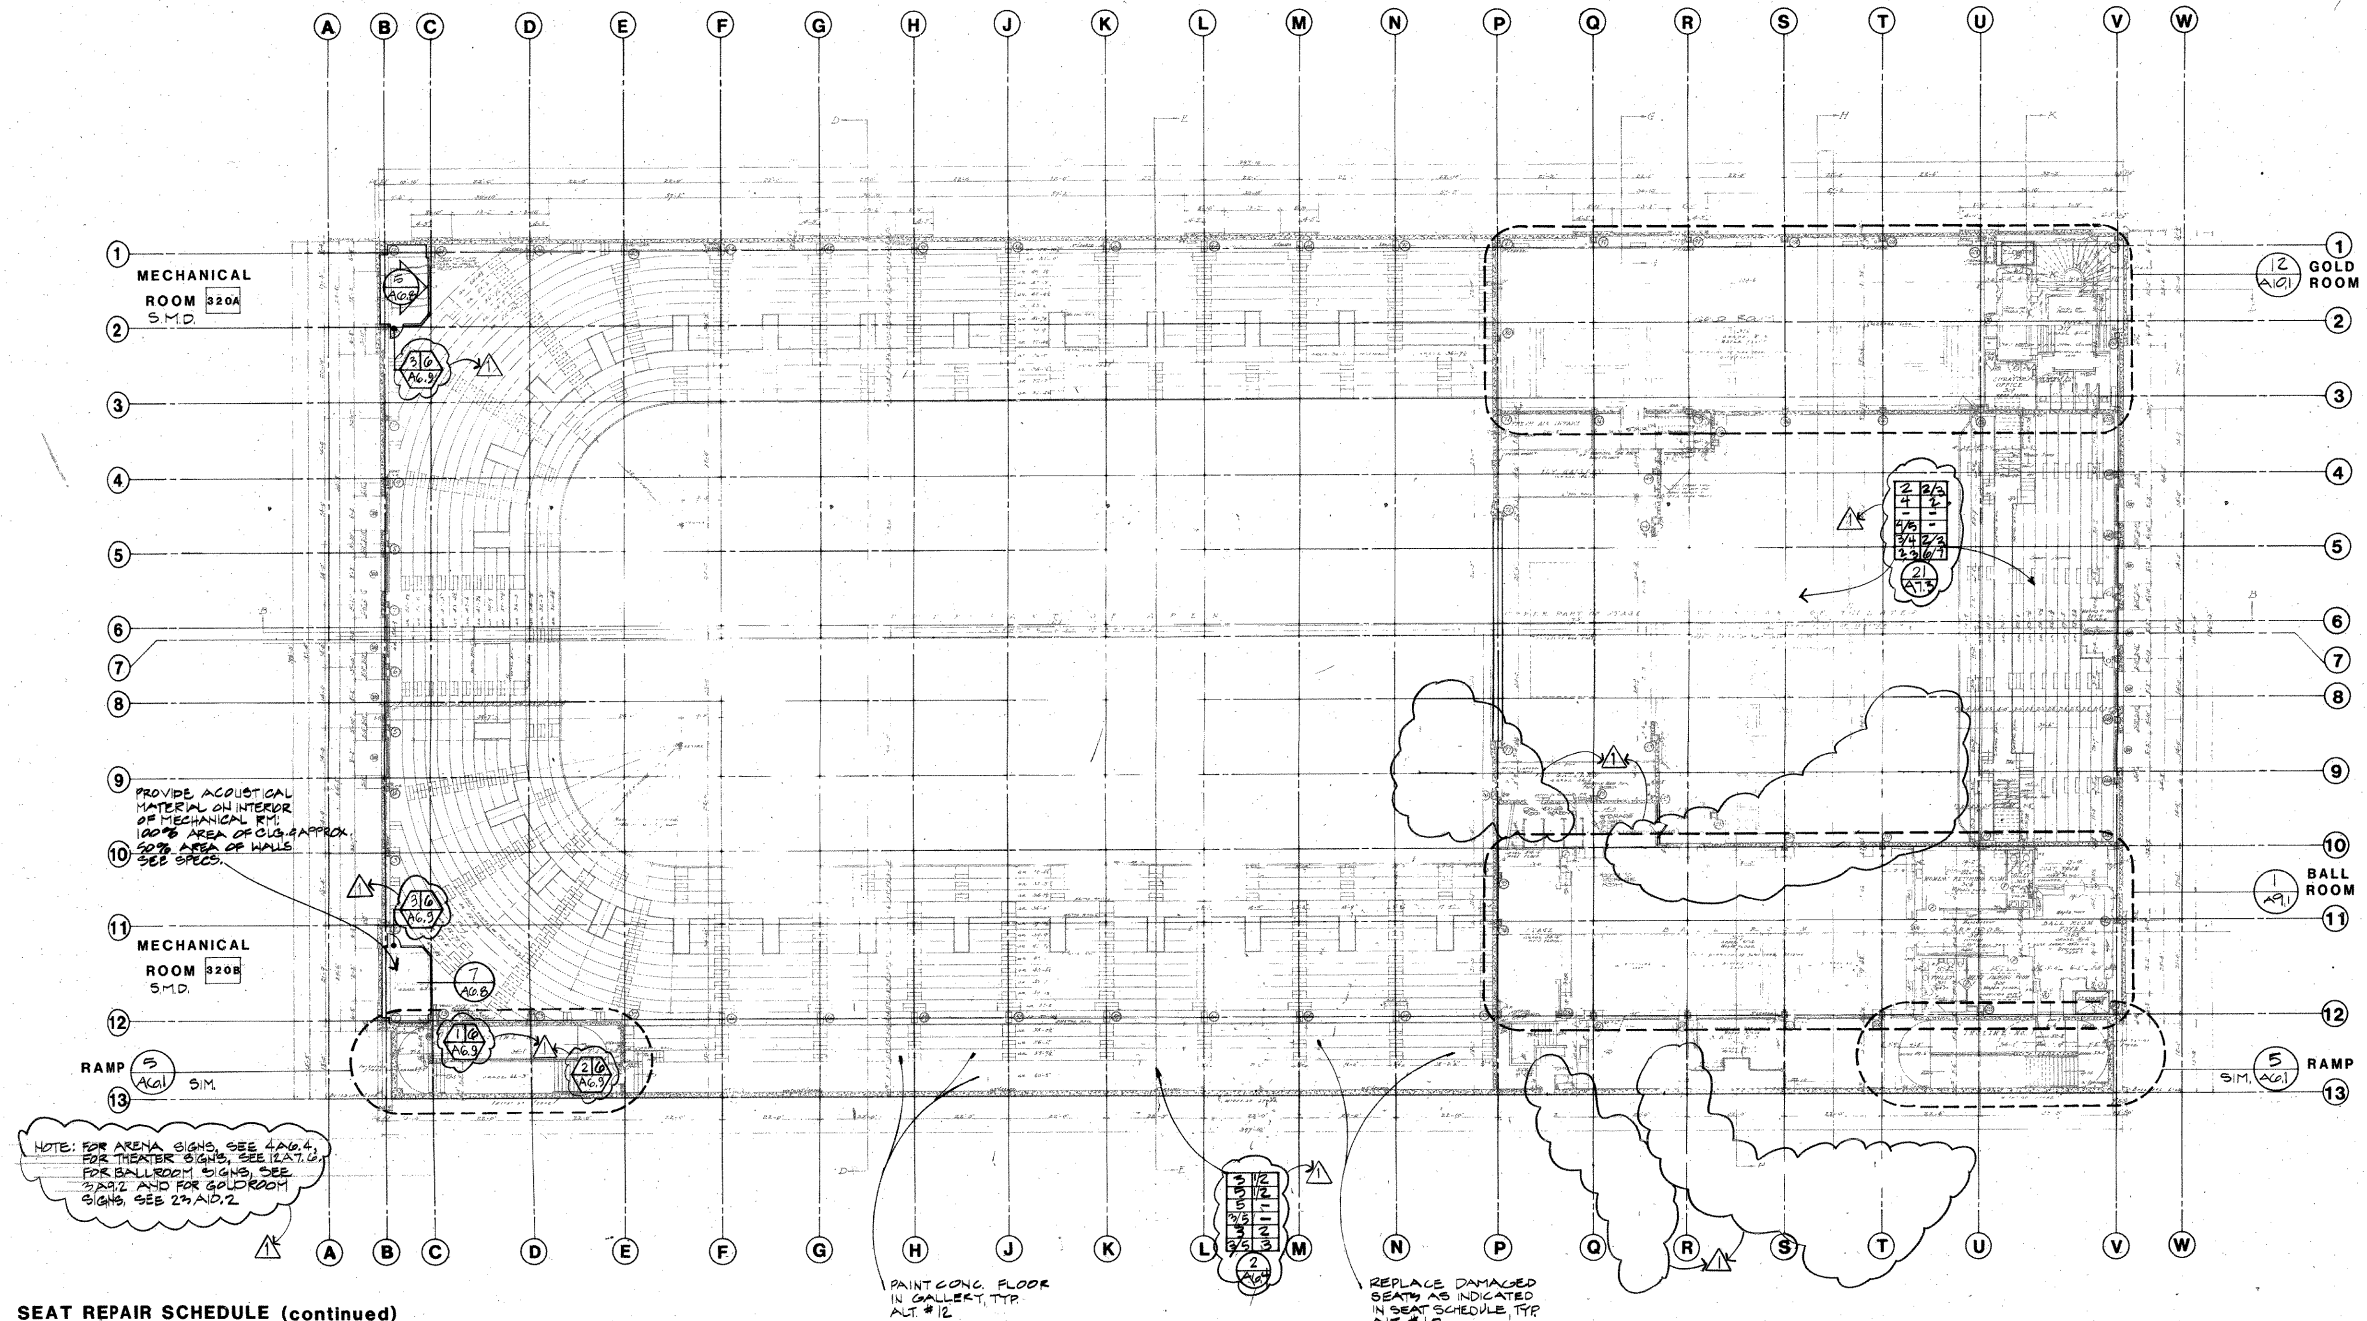

SEAT REPAIR SCHEDULE (continued)

SECTION	SEAT NO.	SEAT	BACK	ARM	REST	WALL	CONN.	SECTION	SEAT NO.	SEAT	BACK	ARM	REST	WALL	CONN.
15	F11	x	x	x	x	x	x	23	B1	x	x	x	x	x	x
	G1	x	x	x	x	x	x		B9	x	x	x	x	x	x
	G5	x	x	x	x	x	x		B11	x	x	x	x	x	x
	G7	x	x	x	x	x	x		C7	x	x	x	x	x	x
	J17	x	x	x	x	x	x		C9	x	x	x	x	x	x
	A5	x	x	x	x	x	x		C11	x	x	x	x	x	x
	A7	x	x	x	x	x	x		D11	x	x	x	x	x	x
	A9	x	x	x	x	x	x		G3	x	x	x	x	x	x
	D11	x	x	x	x	x	x		J25	x	x	x	x	x	x
	E7	x	x	x	x	x	x		K3	x	x	x	x	x	x
	E15	x	x	x	x	x	x		M3	x	x	x	x	x	x
	E17	x	x	x	x	x	x		B9	x	x	x	x	x	x
	E19	x	x	x	x	x	x		B13	x	x	x	x	x	x
	G19	x	x	x	x	x	x		G19	x	x	x	x	x	x
	J17	x	x	x	x	x	x		H21	x	x	x	x	x	x
	J19	x	x	x	x	x	x		H23	x	x	x	x	x	x
	J21	x	x	x	x	x	x		J11	x	x	x	x	x	x
	J23	x	x	x	x	x	x		J19	x	x	x	x	x	x
17	D7	x	x	x	x	x	x								
	D9	x	x	x	x	x	x								
	F3	x	x	x	x	x	x								
	F5	x	x	x	x	x	x								
	F7	x	x	x	x	x	x								
	F19	x	x	x	x	x	x								
	F21	x	x	x	x	x	x								
	J1	x	x	x	x	x	x								
	J25	x	x	x	x	x	x								
19	D13	x	x	x	x	x	x								
	D17	x	x	x	x	x	x								
	J17	x	x	x	x	x	x								
21	A1	x	x	x	x	x	x								
	B1	x	x	x	x	x	x								
	F1	x	x	x	x	x	x								
	F7	x	x	x	x	x	x								
	J1	x	x	x	x	x	x								
	J5	x	x	x	x	x	x								

The Ratcliff Architects

8117 GROVE ST. OAKLAND, CA 94609
PHONE: (415) 652-1872

DRAWN: *Burke* CHECKED: *Burke*
PROJECT DIRECTOR: *Burke*

ASSOCIATED ARCHITECTS:
Ishimaru Design Group
488 25TH ST.
OAKLAND, CA 94612 (415) 839-8313

STRUCTURAL ENGINEERS:
H. J. Degenkolb Associates
350 SANSOME ST., SUITE 500
SAN FRANCISCO, CA 94104 (415) 392-8952

ASSOCIATED STRUCTURAL ENGINEERS:
Jordan-Avent & Associates

MECHANICAL ENGINEERS:
JYA Consulting Engineers
50 BRANNAN ST.
SAN FRANCISCO, CA 94107 (415) 543-8411

ASSOCIATED MECHANICAL ENGINEERS:
Pyramid Designs

ELECTRICAL ENGINEERS:
Ray I. Juachon & Associates
65 SHERIDAN ST.
SAN FRANCISCO, CA 94103 (415) 552-4832

LIGHTING:
Marlene Lee Lighting Design Consulting Engineers
573 MISSION ST.
SAN FRANCISCO, CA 94105 (415) 546-7885

18 AUG 1982 ADDENDUM #1

Henry J. Kaiser Convention Center
10-10TH ST.
OAKLAND, CA 94607


ROOF PLAN

64 48 32 24 16 8 4 0

PROJECT NO. 8129 DRAWING NO.

A3.5

DATE 23 JULY 1982

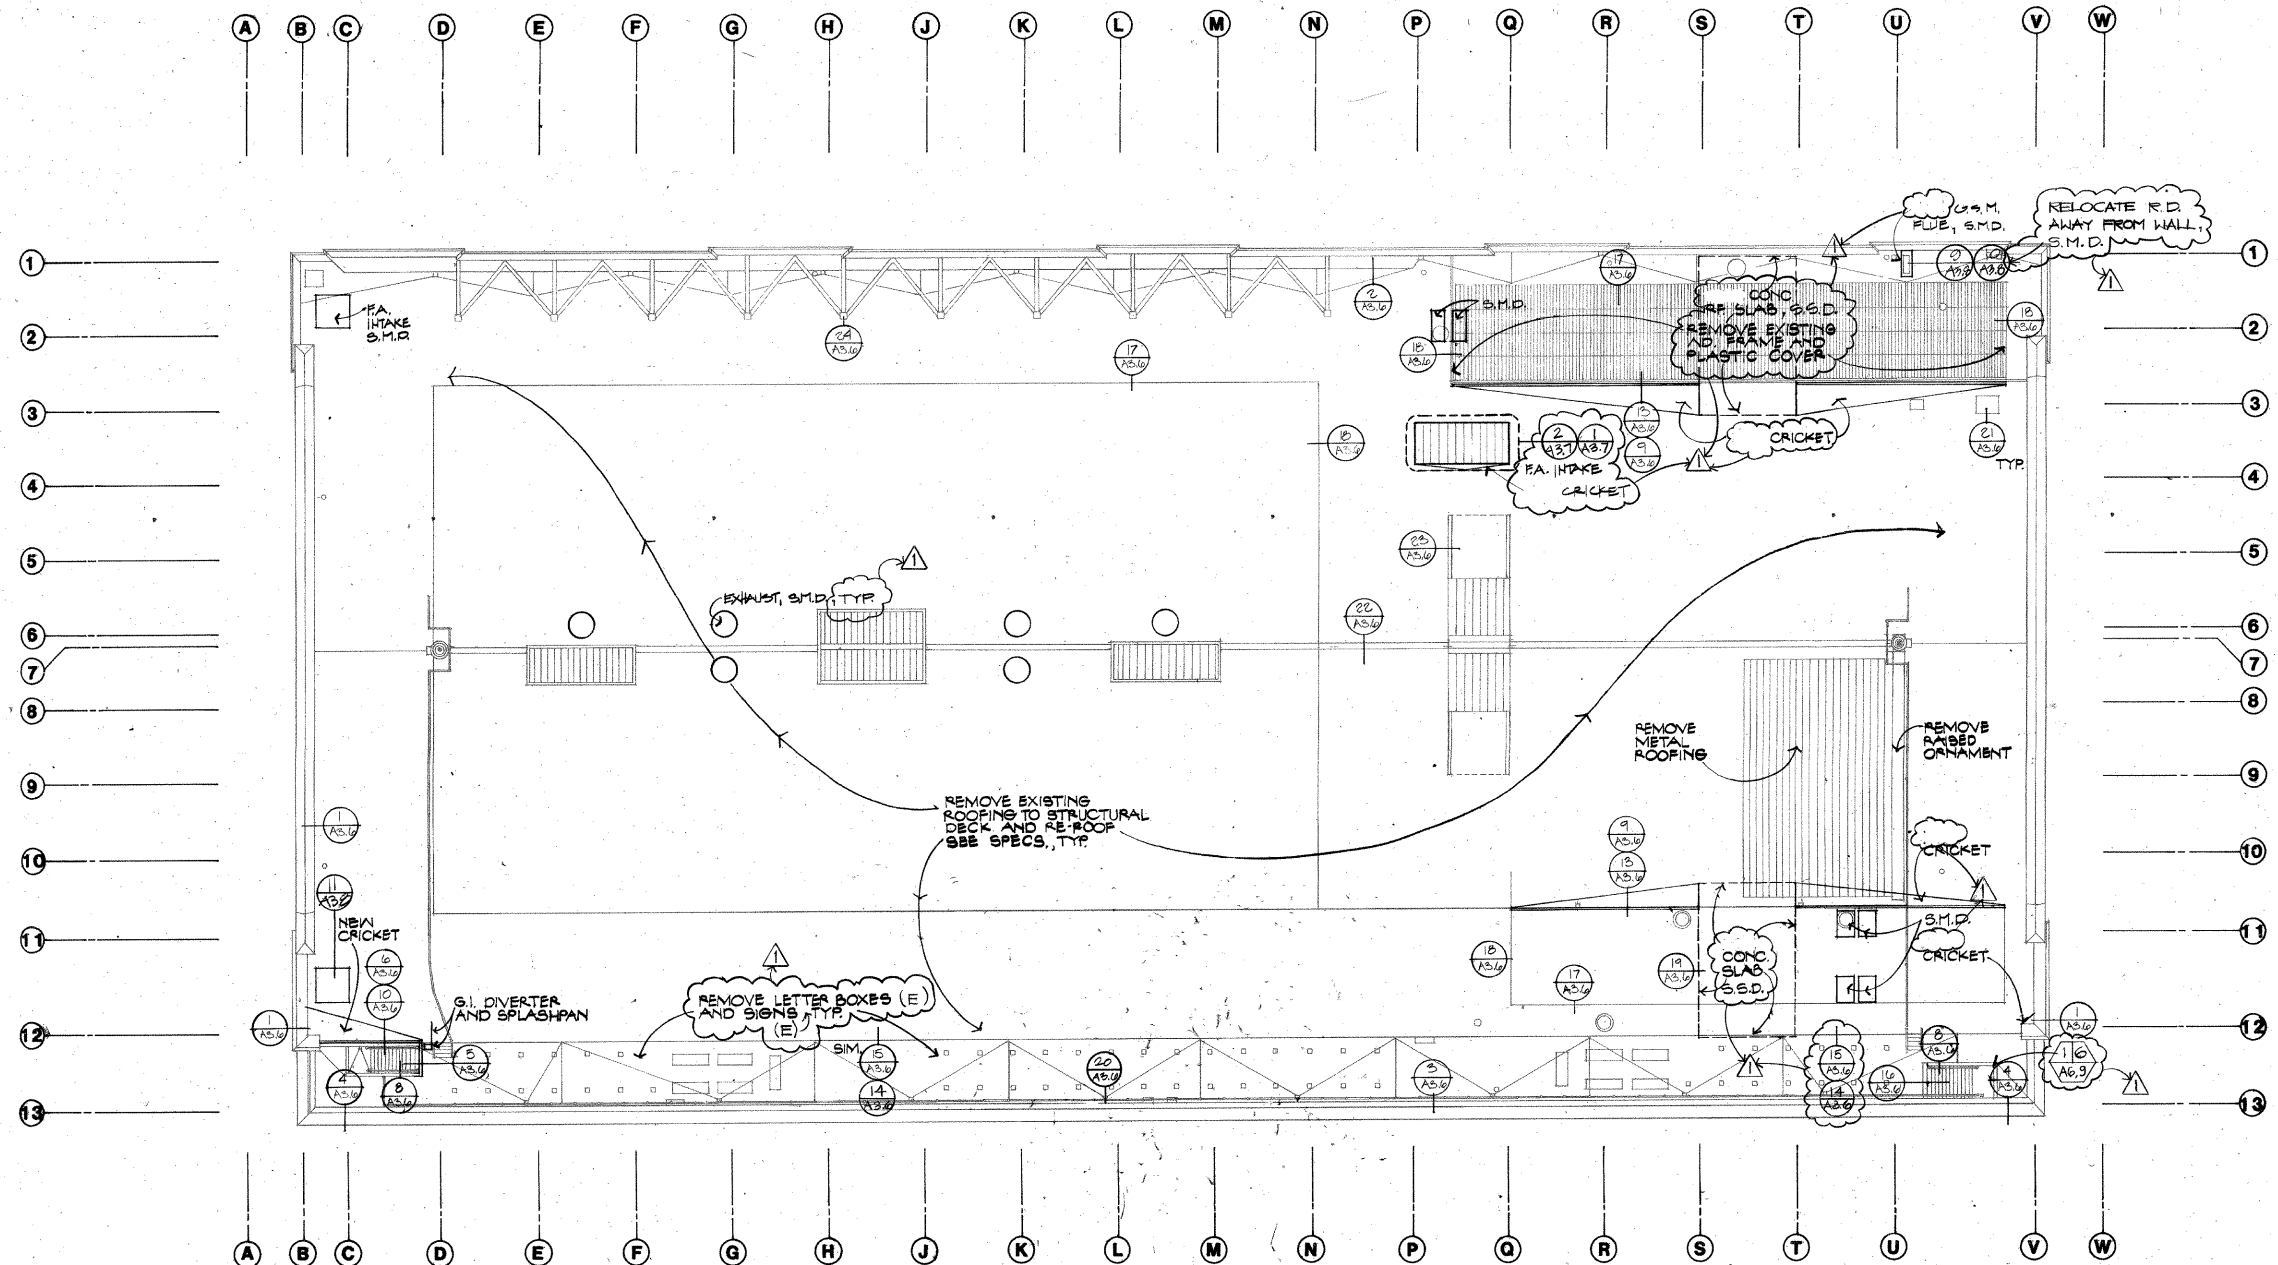

6117 GROVE ST. OAKLAND, CA. 94609
PHONE: (415) 852 1972
DRAWN CHECKED
PRINCIPAL PROJECT DIRECTOR

STRUCTURAL ENGINEERS

H. J. Degenkolb Associates

350 SANSOME ST., SUITE 500
SAN FRANCISCO, CA 94104 (415) 392-6951

MECHANICAL ENGINEERS

JYA Consulting Engineers

50 BRANNAN ST.
SAN FRANCISCO, CA 94107 (415) 543-8411

ELECTRICAL ENGINEERS

Ray I. Juachon & Associates

65 SHERIDAN ST.
SAN FRANCISCO, CA 94103 (415) 552-4832

LIGHTING

**Marlene Lee Lighting Design
Consulting Engineers**

573 MISSION ST.
SAN FRANCISCO, CA 94105 (415) 546-7885

**Henry J. Kaiser
Convention Center**
10-10TH ST.
OAKLAND, CA 94607


32 24 16 12 8 4 2 0

PROJECT NO. 8129

DRAWING NO

A4.1

DATE: 23 JULY 1982

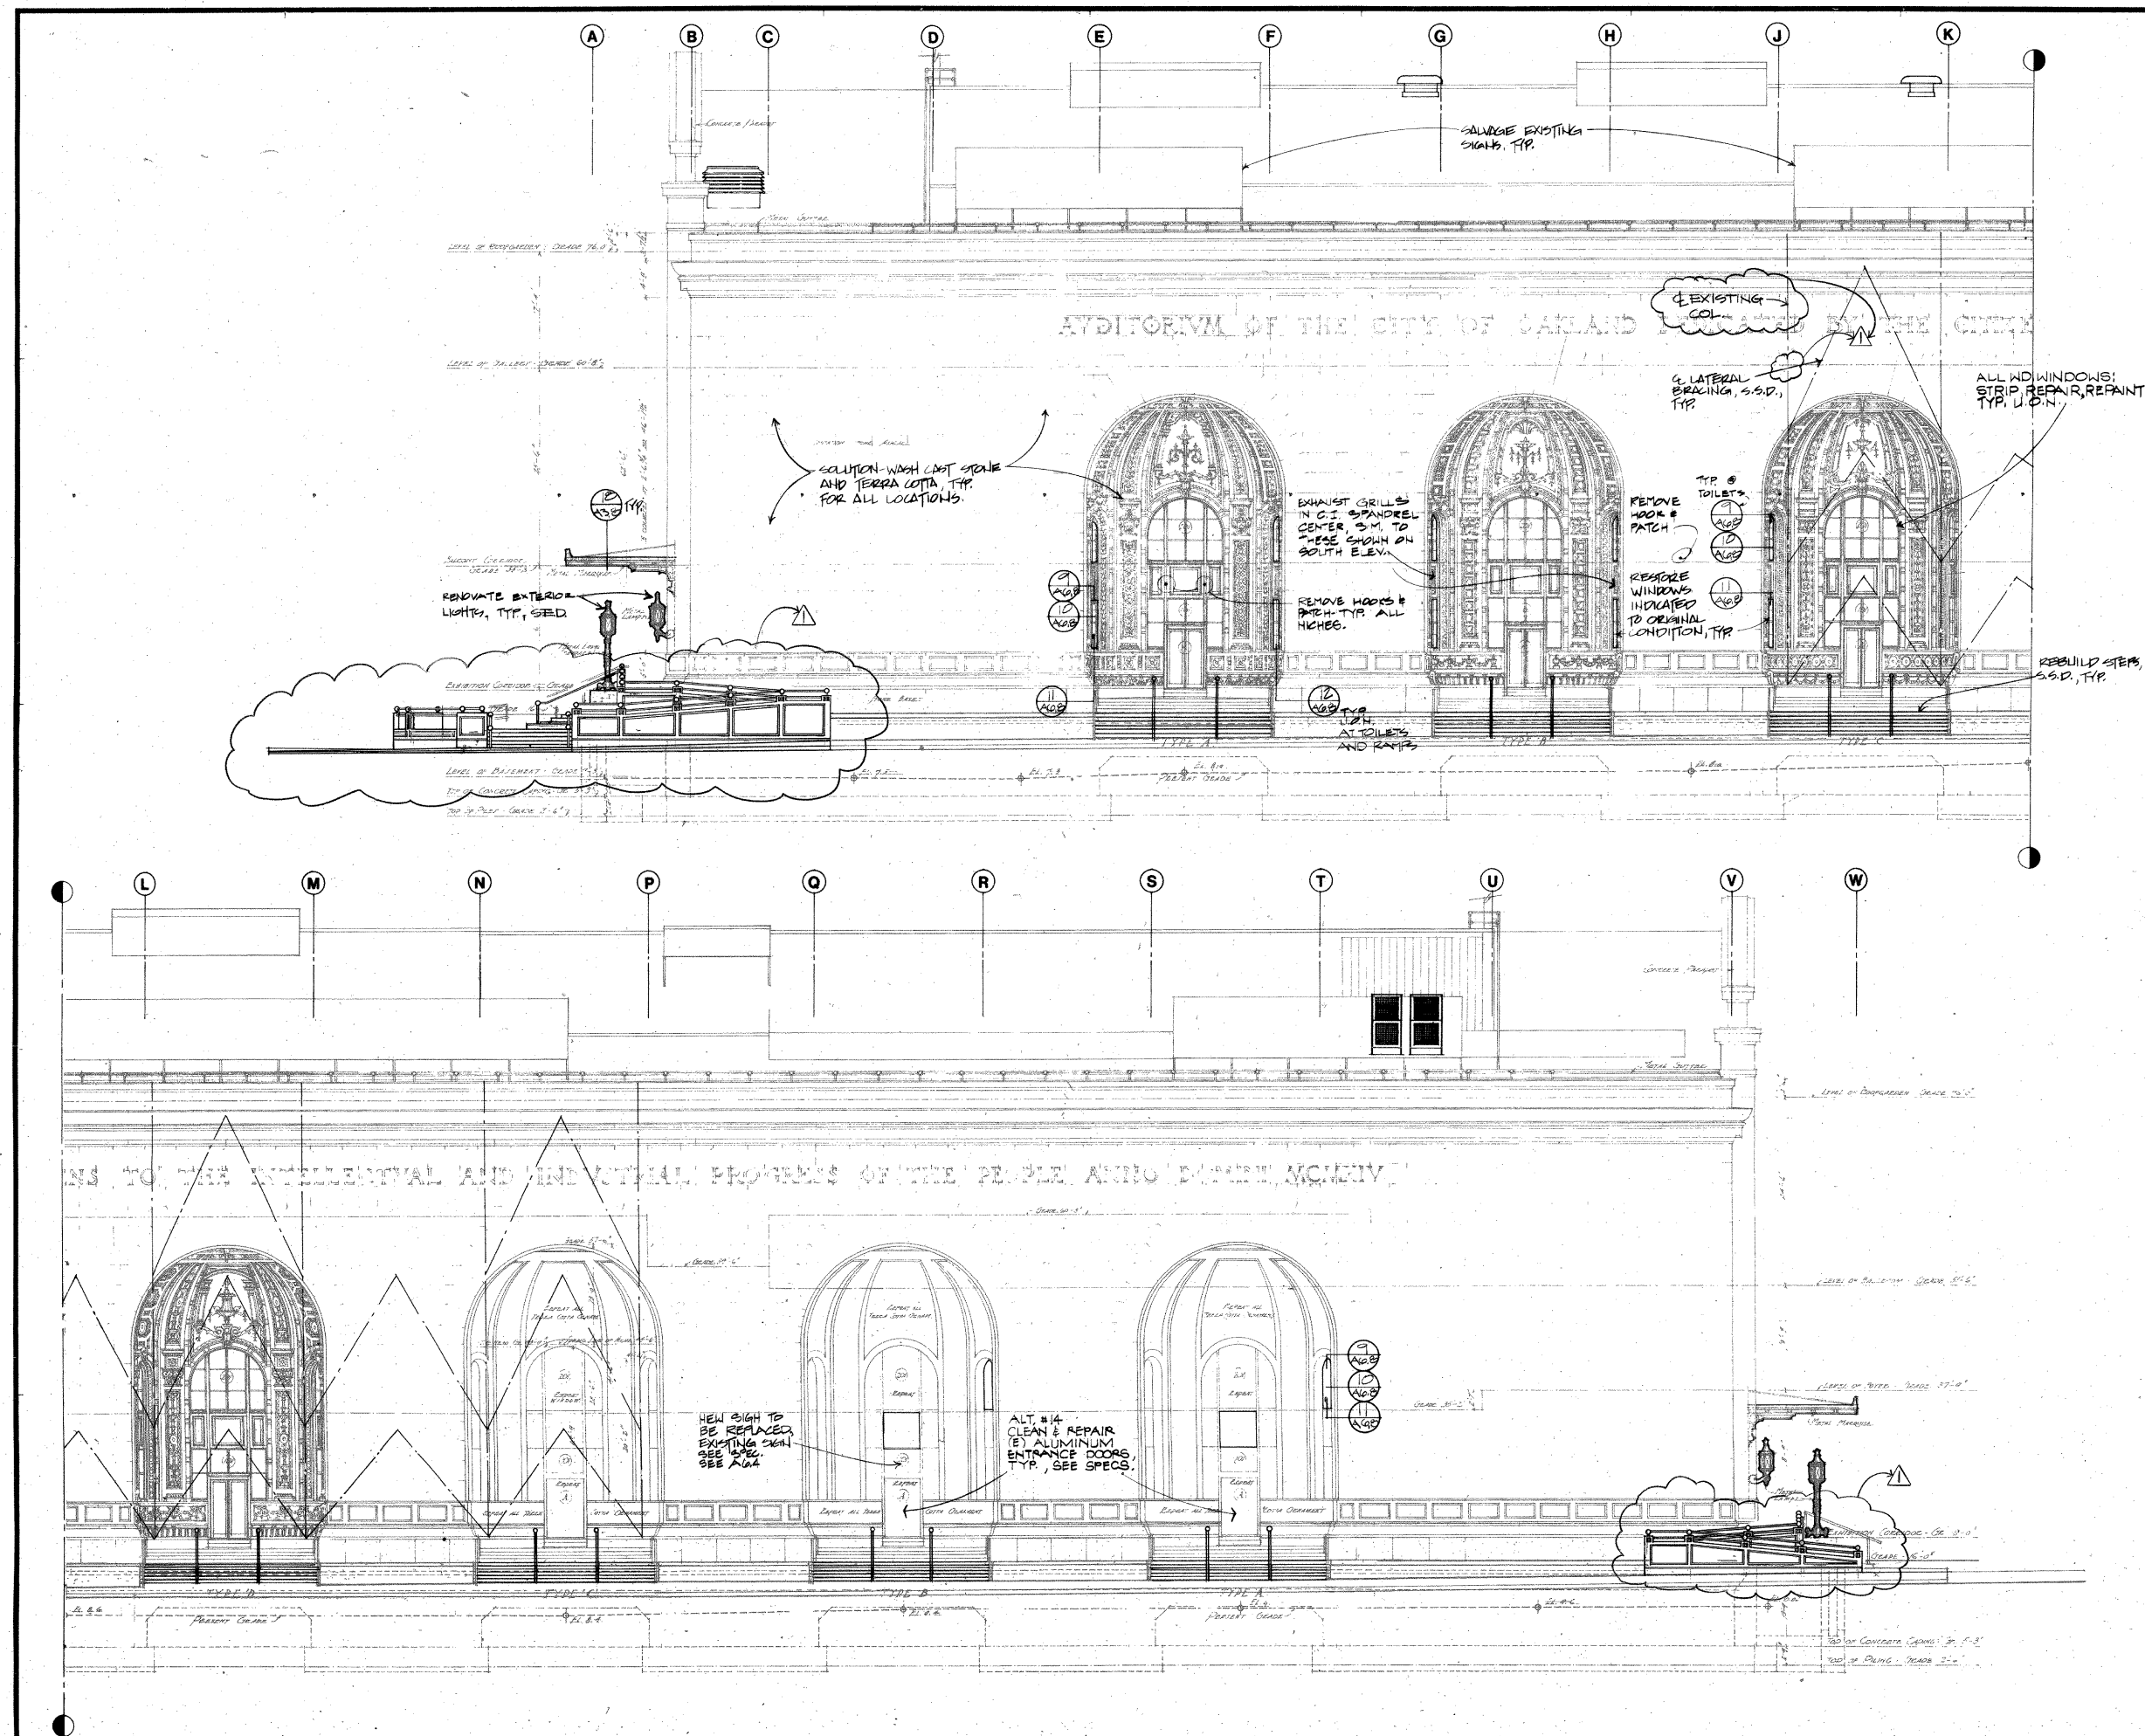

The Ratcliff Architects

6117 GROVE ST. OAKLAND, CA 94609
PHONE: (415) 852-1872

DRAWN: *Sam Levenson* CHECKED: *Sam Levenson*
PROJECT DIRECTOR: *Sam Levenson*

ASSOCIATED ARCHITECTS:
Ishimaru Design Group
488 25TH ST.
OAKLAND, CA 94612 (415) 839-8313

STRUCTURAL ENGINEERS:
H. J. Degenkolb Associates
350 SANSOME ST., SUITE 500
SAN FRANCISCO, CA 94104 (415) 392-6952

ASSOCIATED STRUCTURAL ENGINEERS:
Jordan-Avent & Associates

MECHANICAL ENGINEERS:
JYA Consulting Engineers
50 BRANNAN ST.
SAN FRANCISCO, CA 94107 (415) 543-8411

ASSOCIATED MECHANICAL ENGINEERS:
Pyramid Designs

ELECTRICAL ENGINEERS:
Ray I. Juachon & Associates
65 SHERIDAN ST.
SAN FRANCISCO, CA 94103 (415) 552-4832


LIGHTING:
Marlene Lee Lighting Design Consulting Engineers
573 MISSION ST.
SAN FRANCISCO, CA 94105 (415) 546-7885

13 AUG. 1982 APPENDIX #1

Henry J. Kaiser Convention Center
10-10TH ST.
OAKLAND, CA 94607

SOUTH ELEVATION

32 24 16 12 8 4 2 0
PROJECT NO. 8129 DRAWING NO. **A4.2**
DATE: 23 JULY 1982

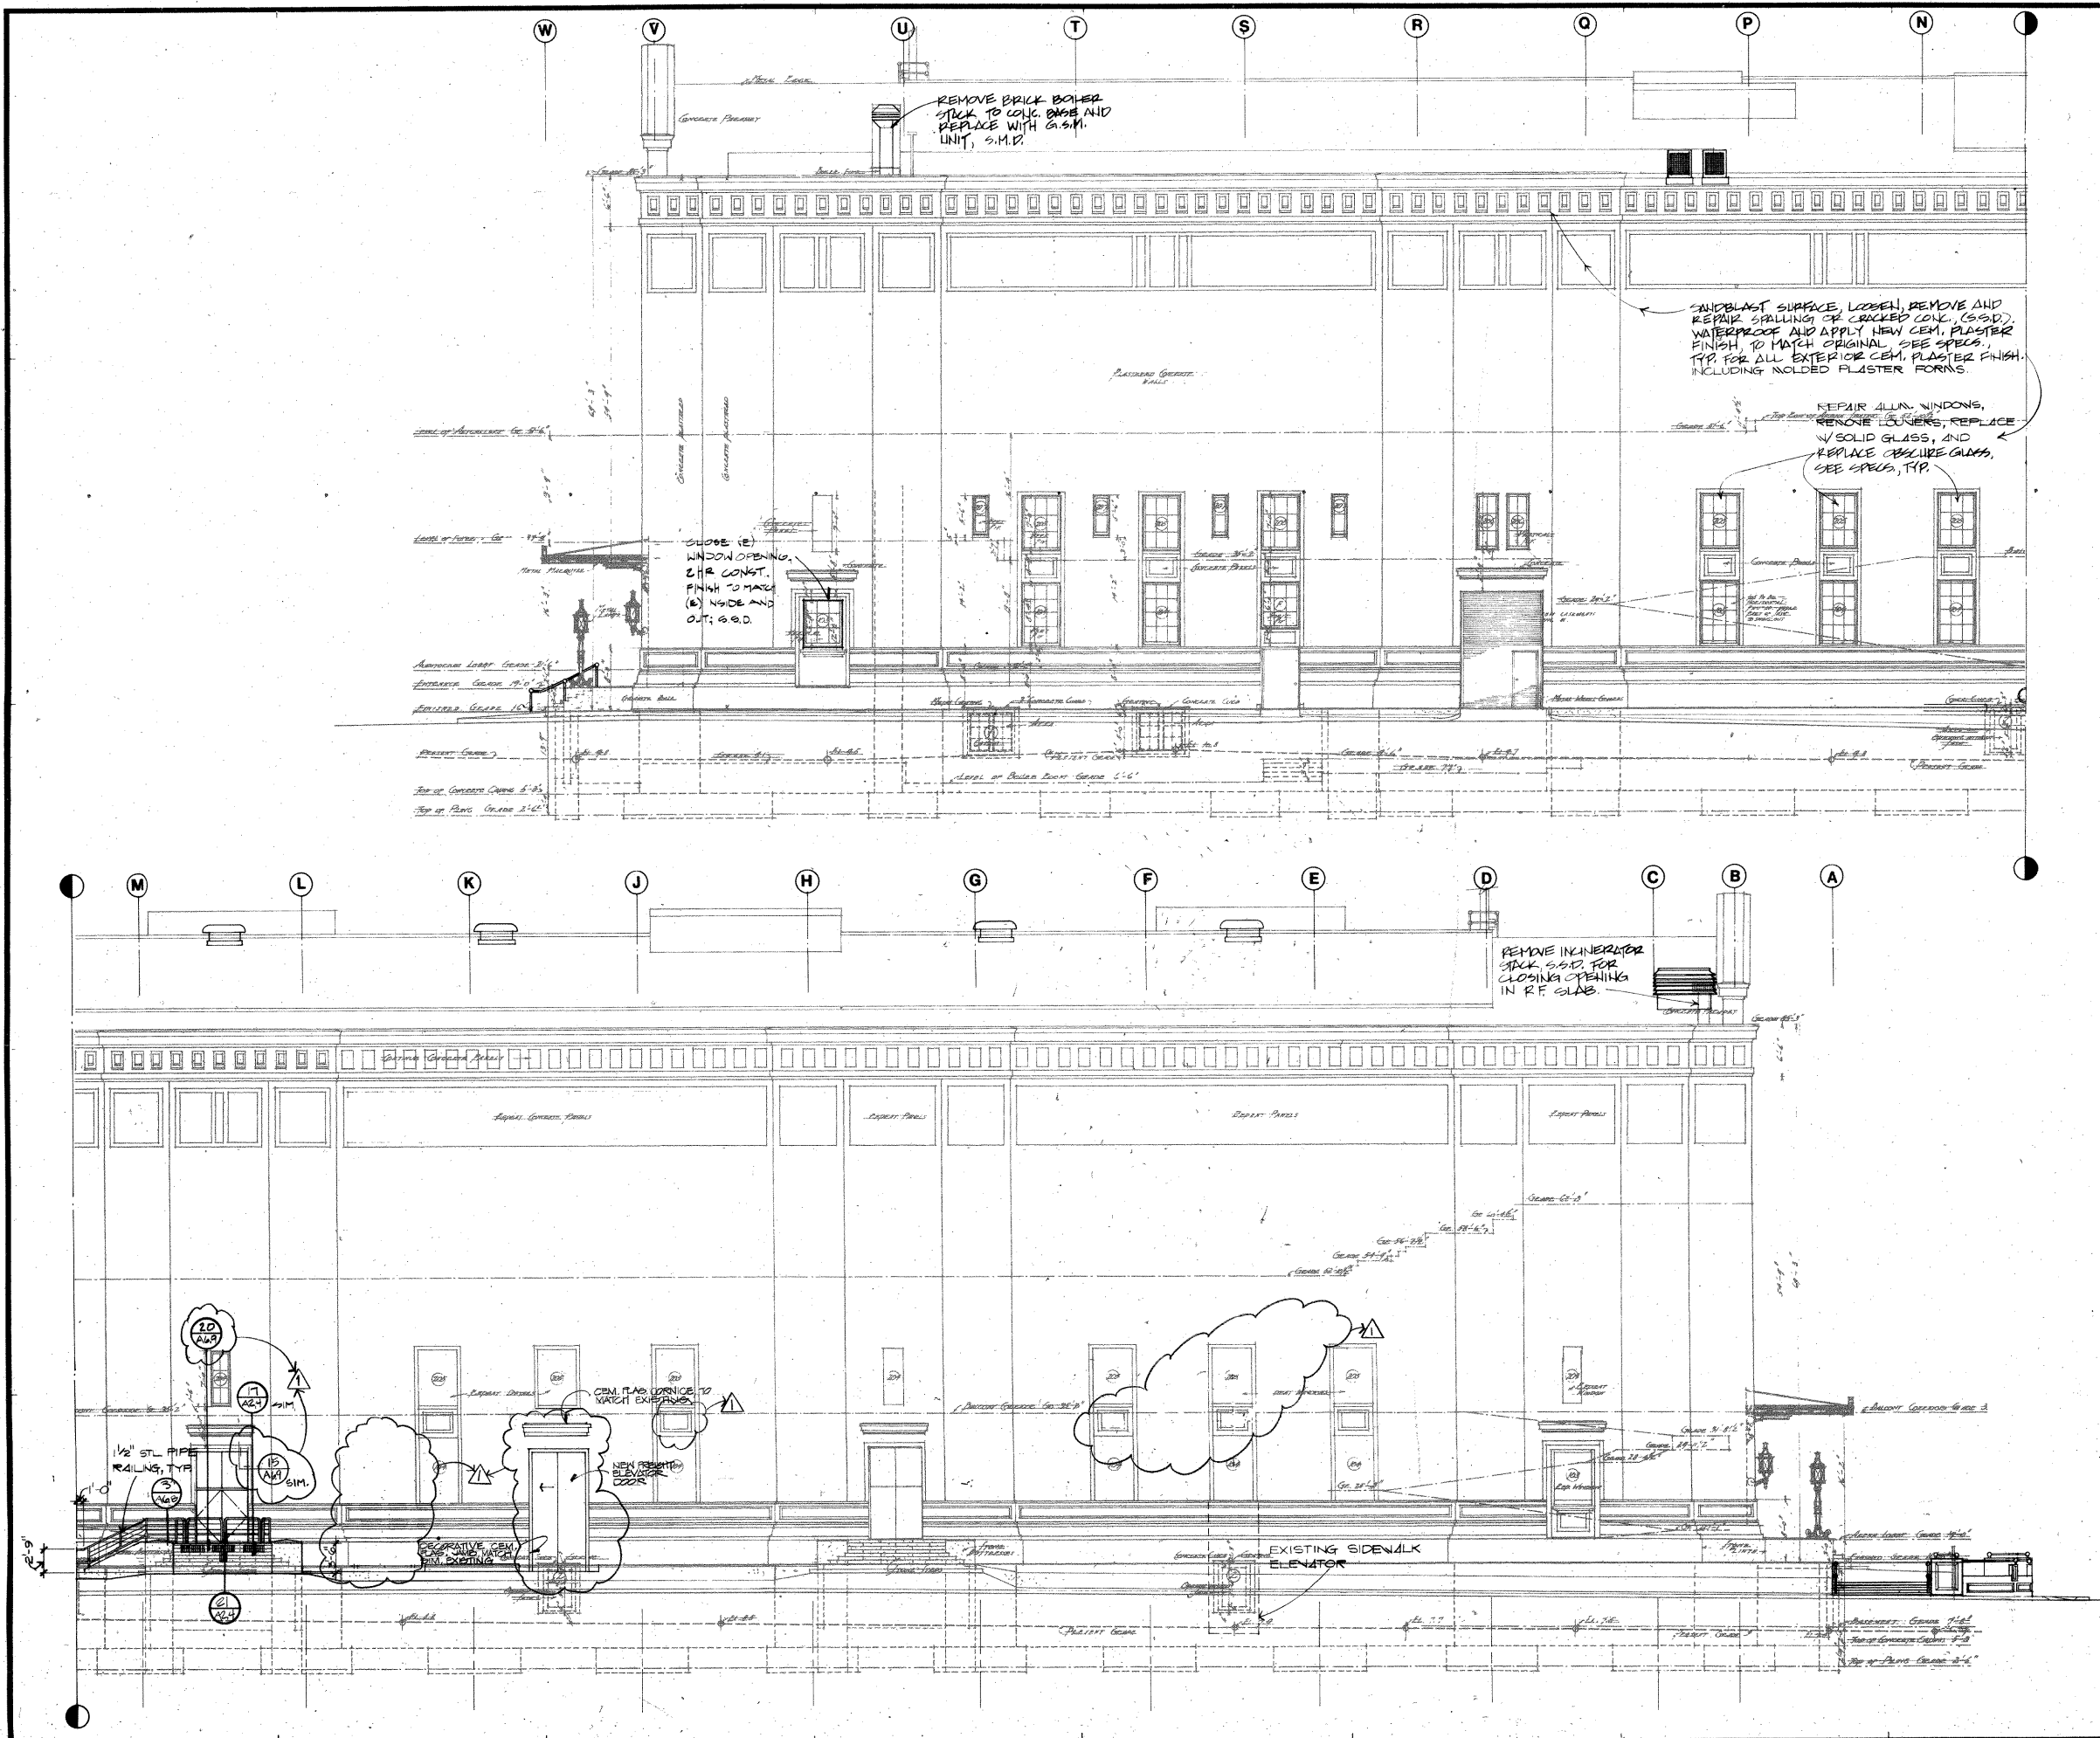

The Ratcliff Architects

8117 GROVE ST. OAKLAND, CA 94609
PHONE: (415) 852-1972

DRAWN: *[Signature]* CHECKED: *[Signature]*
PROJECT DIRECTOR: *[Signature]*

ASSOCIATED ARCHITECTS:
Ishimaru Design Group
468 25TH ST.
OAKLAND, CA 94612 (415) 839-8313

STRUCTURAL ENGINEERS
H. J. Degenkolb Associates
350 SANSOME ST., SUITE 500
SAN FRANCISCO, CA 94104 (415) 392-6952

ASSOCIATED STRUCTURAL ENGINEERS
Jordan-Avent & Associates

MECHANICAL ENGINEERS
JYA Consulting Engineers
50 BRANNAN ST.
SAN FRANCISCO, CA 94107 (415) 548-8411

ASSOCIATED MECHANICAL ENGINEERS
Pyramid Designs

ELECTRICAL ENGINEERS
Ray I. Juachon & Associates
65 SHERIDAN ST.
SAN FRANCISCO, CA 94103 (415) 552-4832

LIGHTING
Marlene Lee Lighting Design Consulting Engineers
573 MISSION ST.
SAN FRANCISCO, CA 94105 (415) 546-7885

18 AUG 1982 ADDENDUM #1


Henry J. Kaiser
Convention Center
10-10TH ST.
OAKLAND, CA 94607

EAST AND WEST ELEVATIONS


32 24 16 12 8 4 2 0
PROJECT NO. 8129 DRAWING NO.

A4.3

DATE 23 JULY 1982

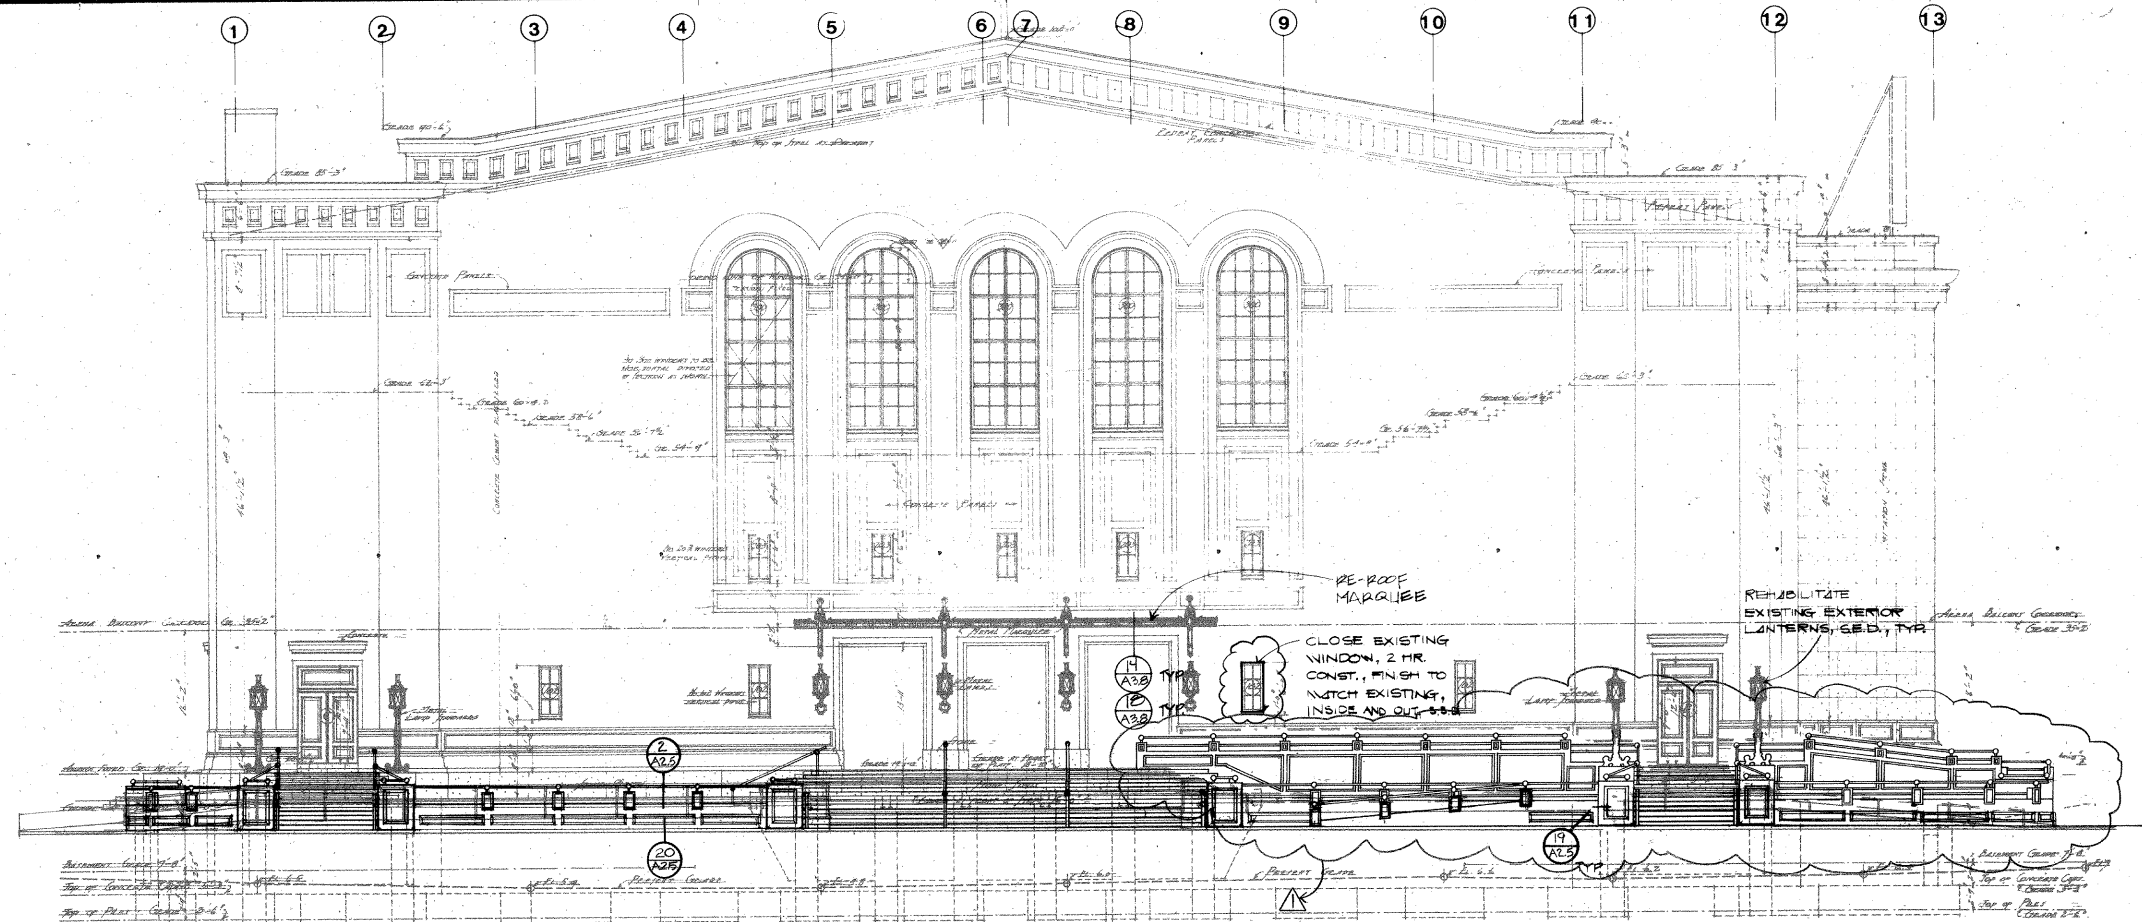

EAST ELEVATION

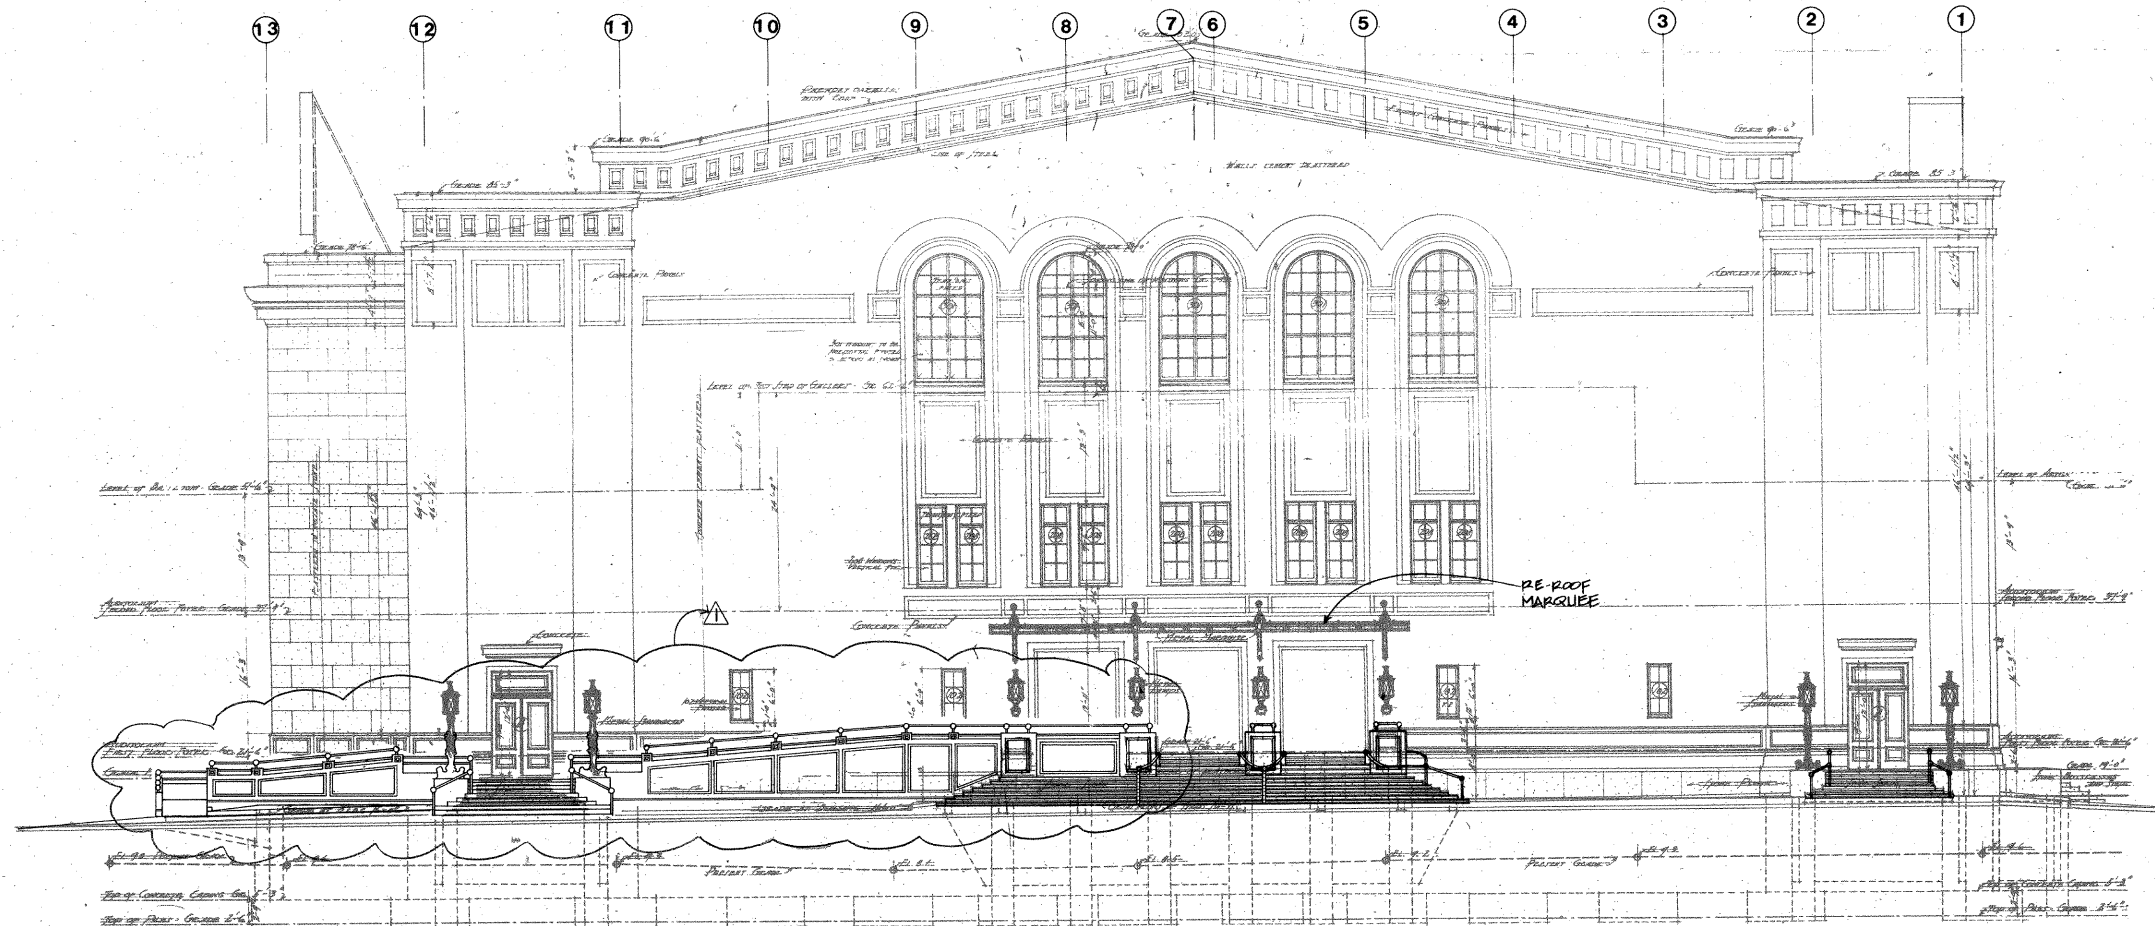

WEST ELEVATION

6117 GROVE ST. OAKLAND, CA. 94609
PHONE: (415) 852 1972

DRAWN CHECKED
PRINCIPAL PROJECT DIRECTOR

STRUCTURAL ENGINEERS
H. J. Degenkolb Associates
350 SANSOME ST., SUITE 500
SAN FRANCISCO, CA 94104 (415) 392-8852

MECHANICAL ENGINEERS
JYA Consulting Engineers
50 BRANNAN ST.
SAN FRANCISCO, CA 94107 (415) 543-8411

ELECTRICAL ENGINEERS
Ray I. Juachon & Associates
65 SHERIDAN ST.
SAN FRANCISCO, CA 94103 (415) 552-4832

LIGHTING

**Marlene Lee Lighting Design
Consulting Engineers**

573 MISSION ST.
SAN FRANCISCO, CA 94105 (415) 546-7885

18 AUG 1982 ADDENDUM #1


**Henry J. Kaiser
Convention Center**
10-10TH ST.
OAKLAND, CA 94607

32 24 16 12 8 4 2 0

PROJECT NO. 8129

A4.4

DATE **23 JULY 1982**

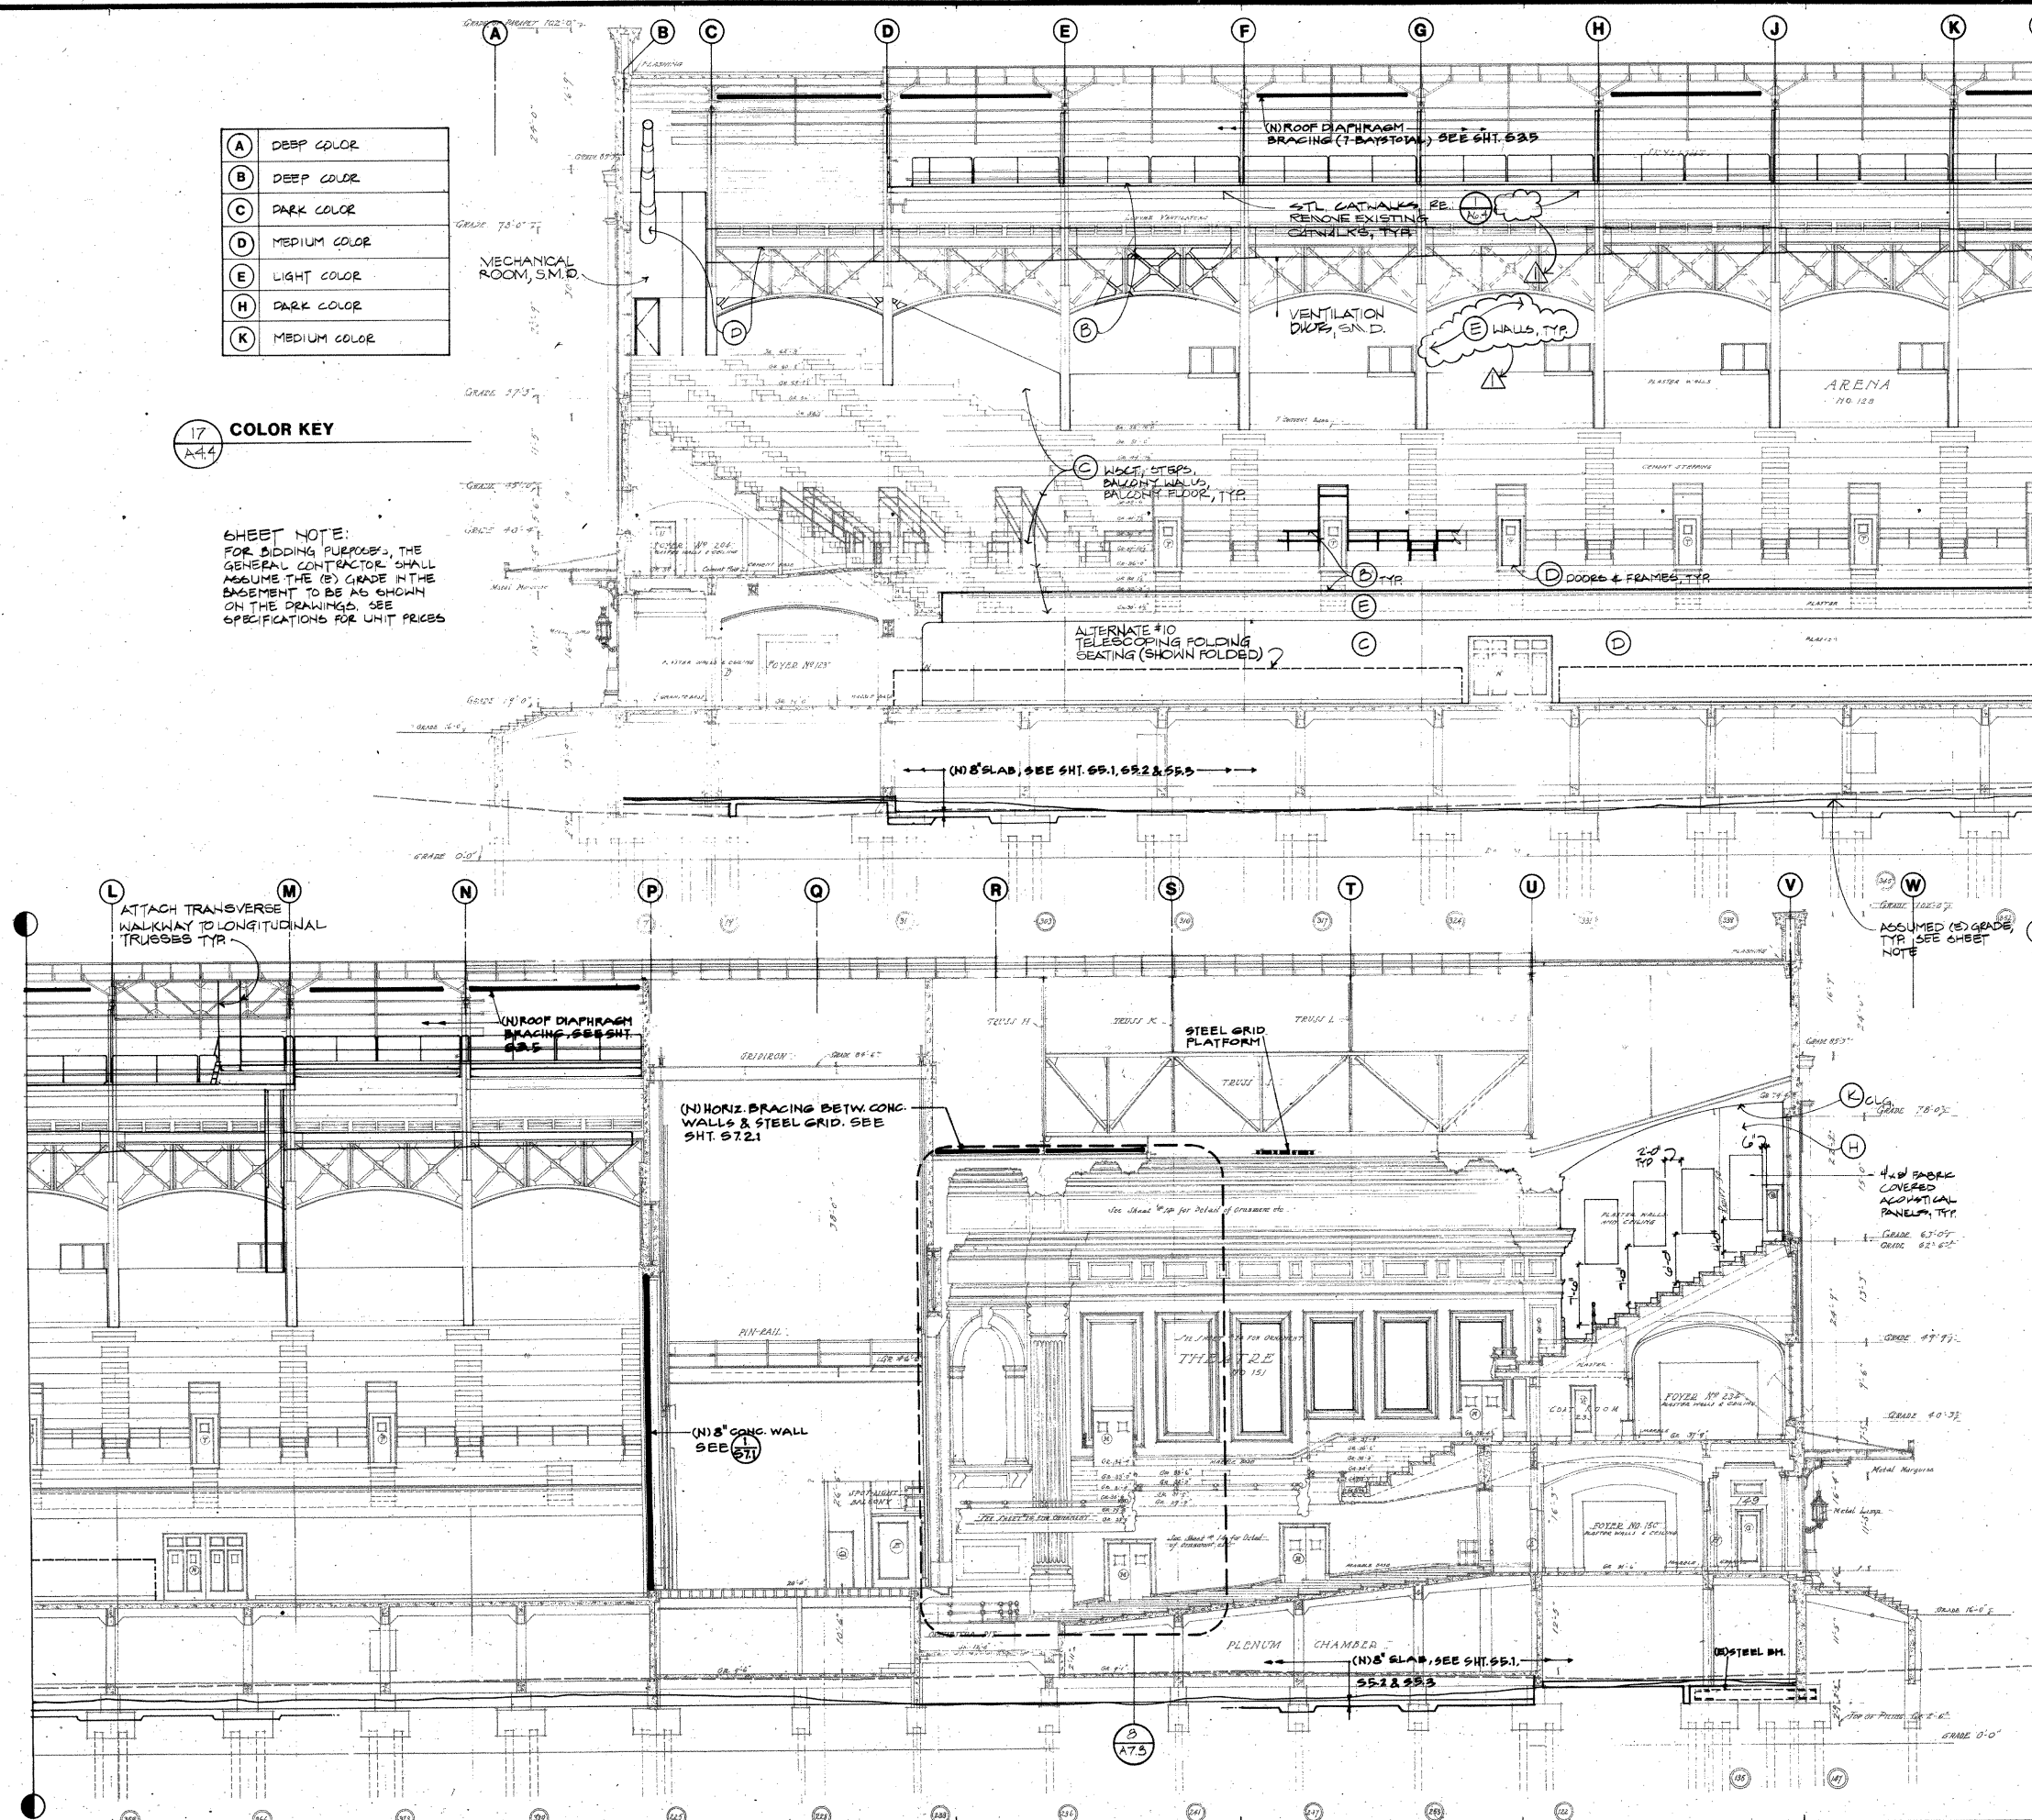

The Ratcliff Architects

8117 GROVE ST. OAKLAND, CA 94609
PHONE (415) 852-1872

DRAWN BY *Paul Jensen* PROJECT DIRECTOR
CHECKED BY *Eric Carlson*

ASSOCIATED ARCHITECTS:
Ishimaru Design Group
488 25TH ST. OAKLAND, CA 94612 (415) 839-8313

STRUCTURAL ENGINEERS:
H. J. Degenkolb Associates
350 SANSOME ST., SUITE 500 SAN FRANCISCO, CA 94104 (415) 392-6952

ASSOCIATED STRUCTURAL ENGINEERS:
Jordan-Avent & Associates

MECHANICAL ENGINEERS:
JYA Consulting Engineers
50 BRANNAN ST. SAN FRANCISCO, CA 94107 (415) 543-8411

ASSOCIATED MECHANICAL ENGINEERS:
Pyramid Designs

ELECTRICAL ENGINEERS:
Ray I. Juachon & Associates
65 SHERIDAN ST. SAN FRANCISCO, CA 94103 (415) 552-4832

LIGHTING:
Marlene Lee Lighting Design Consulting Engineers
573 MISSION ST. SAN FRANCISCO, CA 94105 (415) 548-7885

18 AUG 1982 APPENDUM #1

Henry J. Kaiser Convention Center
10-10TH ST. OAKLAND, CA 94607


ARENA TRANSVERSE SECTION

32 24 16 12 8 4 2 0

PROJECT NO. 8129 DRAWING NO.

A4.5

DATE 23 JULY 1982

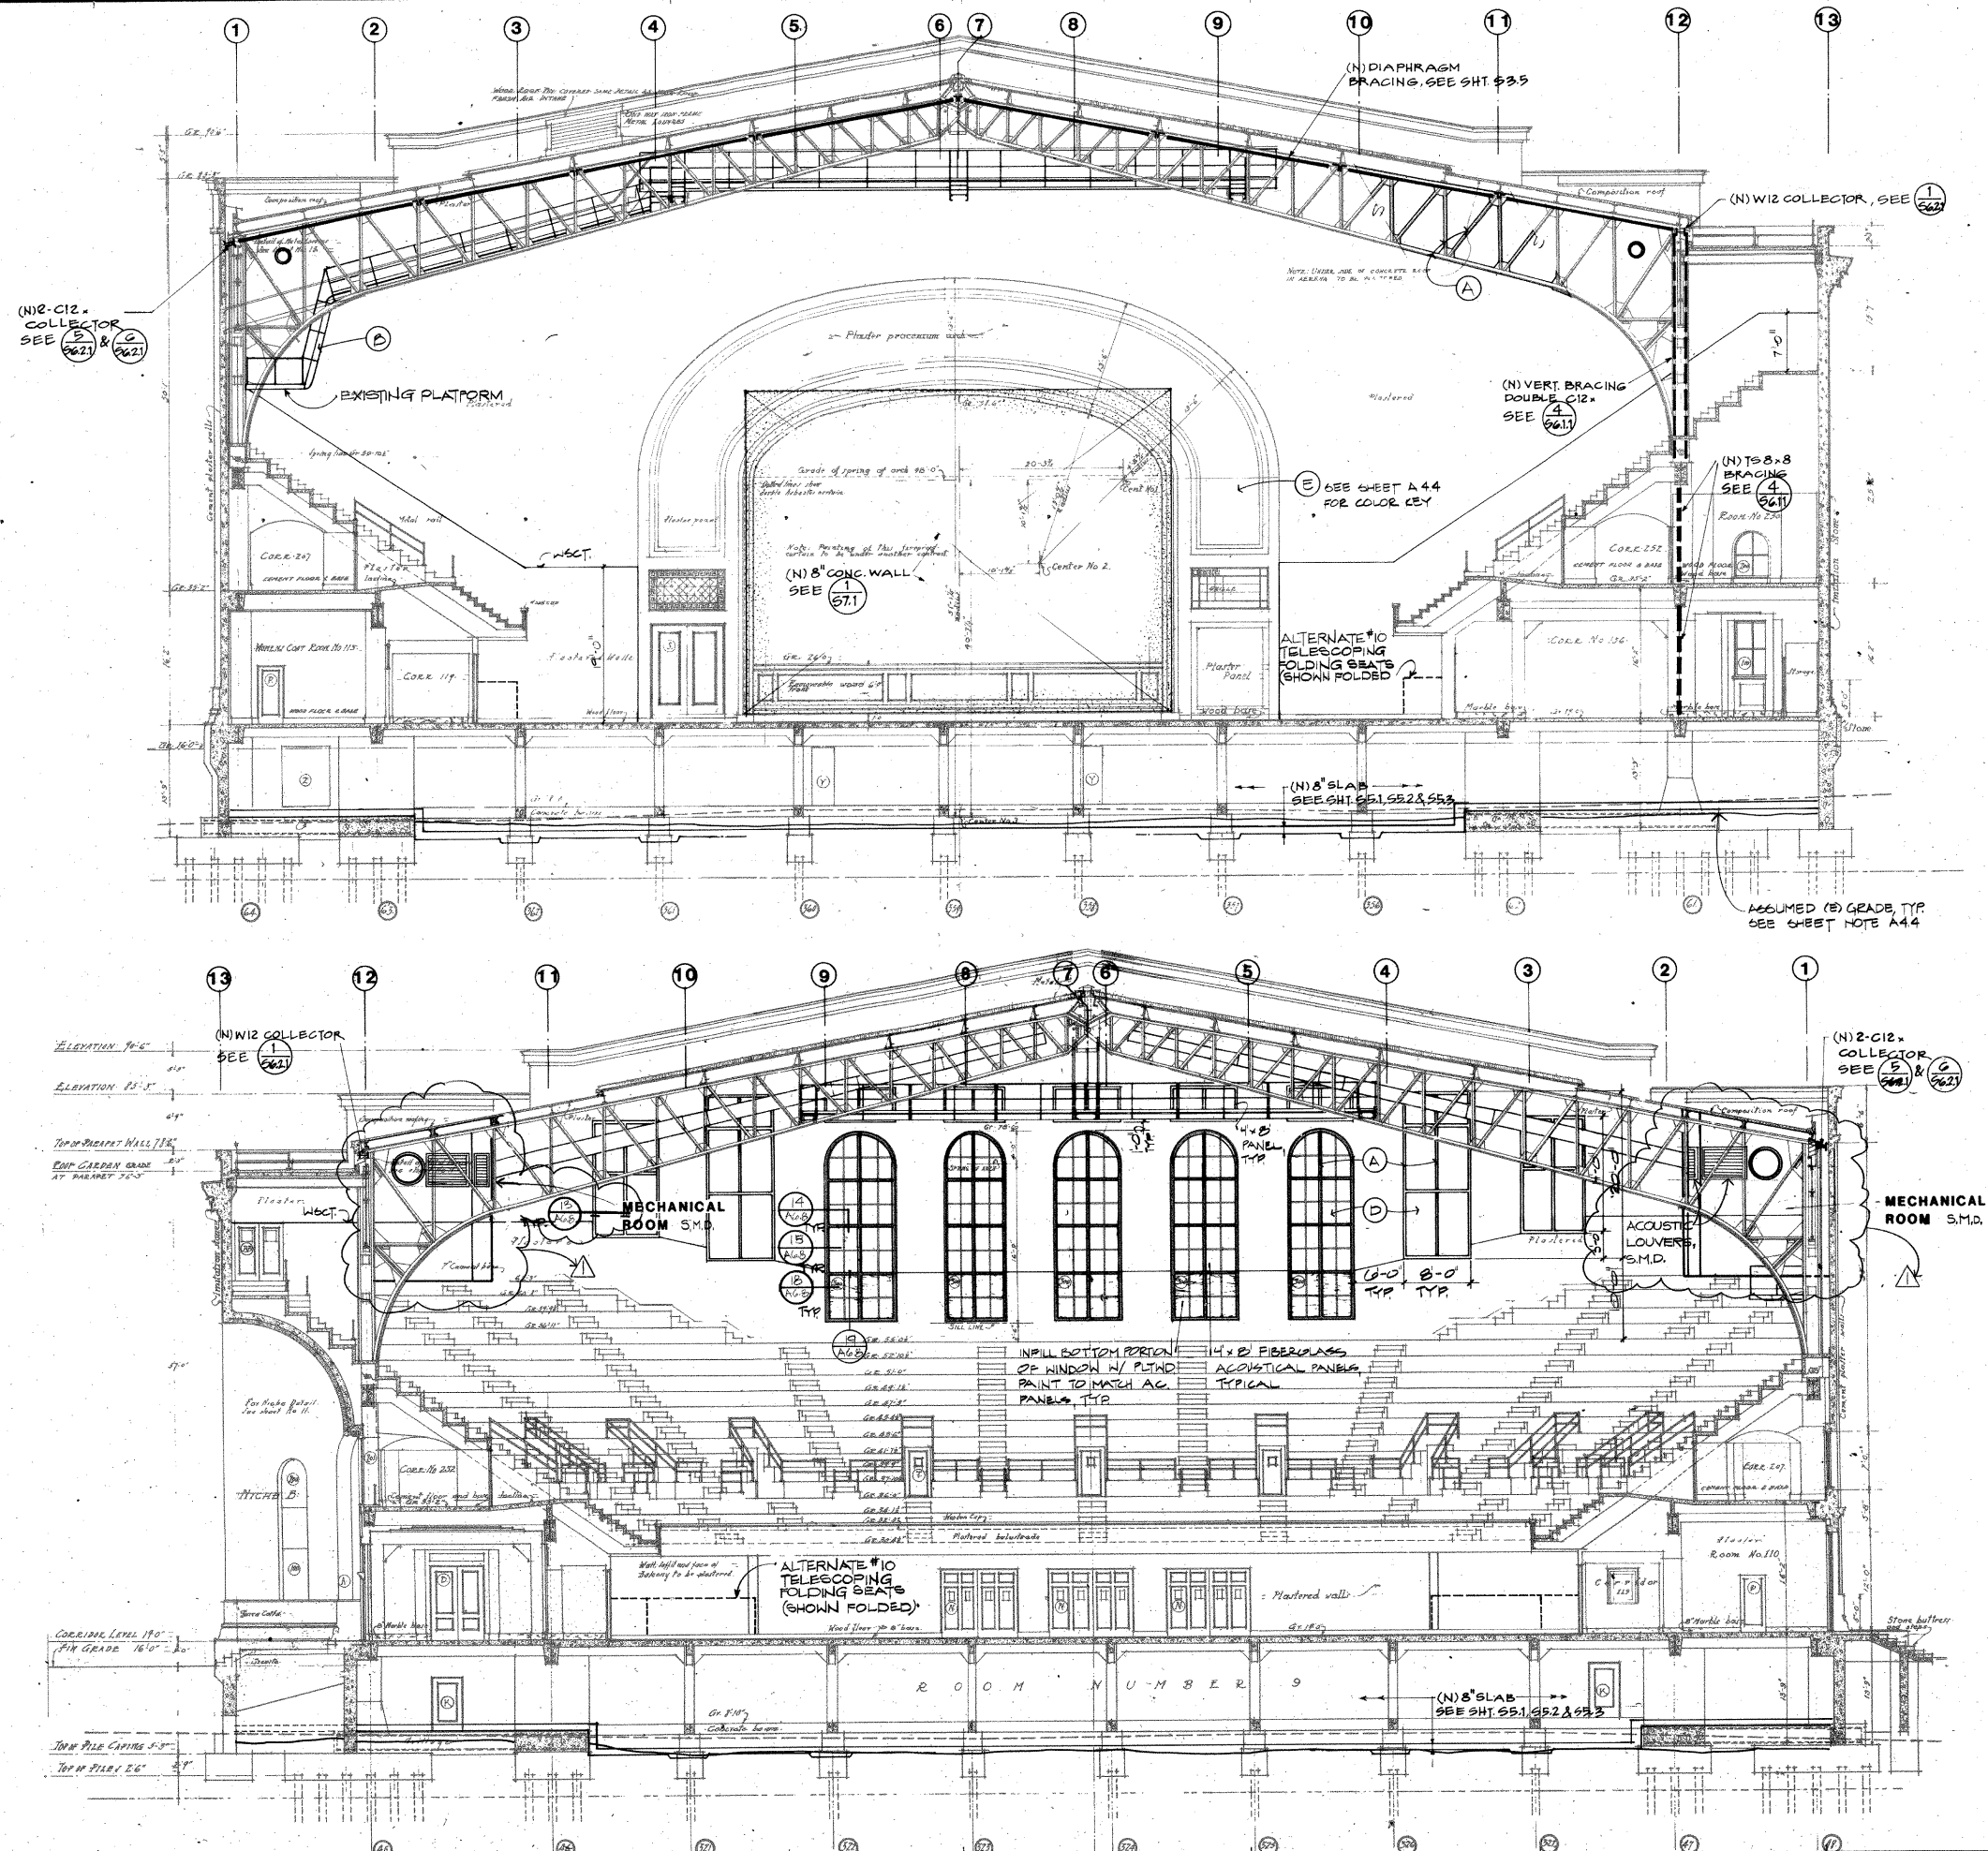

The Ratcliff Architects

6117 GROVE ST. OAKLAND, CA 94609
PHONE: (415) 852-1872

DRAWN: *Sam Lawrence* CHECKED: *Sam Lawrence*
PROJECT: OREGON CASE

ASSOCIATED ARCHITECTS

Ishamar Design Group

468 25TH ST. OAKLAND, CA 94612 (415) 839-8313

STRUCTURAL ENGINEERS

H. J. Degenkolb Associates

350 SANSOME ST., SUITE 500
SAN FRANCISCO, CA 94104 (415) 392-6952

ASSOCIATED STRUCTURAL ENGINEERS

Jordan-Avent & Associates

MECHANICAL ENGINEERS

JYA Consulting Engineers

50 BRANNAN ST. SAN FRANCISCO, CA 94107 (415) 543-8411

ASSOCIATED MECHANICAL ENGINEERS

Pyramid Designs

ELECTRICAL ENGINEERS

Ray I. Juachon & Associates

65 SHERIDAN ST. SAN FRANCISCO, CA 94103 (415) 552-4832

LIGHTING

Marlene Lee Lighting Design

573 MISSION ST. SAN FRANCISCO, CA 94105 (415) 546-7885

18 AUG 1982 APPENDUM #1

Henry J. Kaiser
Convention Center

10-10TH ST.
OAKLAND, CA 94607

THEATER
TRANSVERSE
SECTION

32 24 16 12 8 4 2 0

PROJECT NO. 8129 DRAWING NO.

A4.6

DATE 23 JULY 1982

