 


FUNDED BY
STATE OF CALIFORNIA ACTIVE TRANSPORTATION PROGRAM
CITY PROJECT NO.: 1006182

COUNTY: ALAMEDA

LOCATION MAP

CITY OF OAKLAND COUNCIL DISTRICT MAP



SUITE 4314
OAKLAND, CA 94612
(510) 238-3437
FAX (510) 238-7227

PRINCIPAL CIVIL ENGINEER

SAFE STREETS (DOT)

DIVISION MANAGER

ADA PROGRAM (DOT)

PROGRAM MANAGER

PROJECT DELIVERY DIVISION (OPW)

DIVISION MANAGER

BUREAU OF MAINTENANCE AND INTERNAL
SERVICES (OPW)

ASSISTANT DIRECTOR

BUREAU OF ENVIRONMENT (OPW)

ASSISTANT DIRECTOR

SI LAU, COMPLETE STREETS DESIGN



CHECKED BY VH

CHECKED BY VH

DESIGNED BY	MW	7th s
-------------	----	-------

DRAWN BY MW

No.	BY	DATE	REFERENCE
-----	----	------	-----------

				242
--	--	--	--	-----

				2022

[illegible]

				S\202
--	--	--	--	-------

PROJECT NO. _____ SUBJECT _____

1006102 PRO

1006 102

11/2/2011


SCALE: MTO	SHEET NO. —	Σ
---------------	----------------	---

NIS	T-01	NAM E:
-----	------	-----------

DATE: FEB 01 2004 1 05 46

FEB 01, 2024

INDEX OF SHEETS		
S.NO.	SHEET NO.	SHEET TITLE
1	T-01	COVER SHEET
2	GN-01	GENERAL NOTES, LEGEND, ABBREVIATIONS
3	SC-01	SURVEY CONTROL
4	PP-01	POLLUTION PREVENTION NOTES
5-6	XS-01-XS-02	TYPICAL SECTIONS
X-XX	DM-01-DMXX	DEMOLITION PLANS
7-25	C-01-C-19	CIVIL LAYOUT PLANS
26-32	D-1-D-7	DETAIL SHEETS
XX-XX	C-20-CXX	GRADING PLANS
XX-XX	U-01-UXX	DRAINAGE AND UTILITY PLANS
XX-XX	U-XX-UXX	DRAINAGE PROFILES
XX-XX	CD-01-CDXX	CONSTRUCTION DETAILS
33-40	SS-01-SS-08	SIGNING AND STRIPING
XX-XX	SS-09-SSXX	SIGNING AND STRIPING DETAILS
XX	TS-01	TRAFFIC SIGNAL GENERAL NOTES, LEGEND, ABBREVIATIONS
XX-XX	TS-02-TS-XX	TRAFFIC SIGNAL PLANS
XX-XX	TS-XX-TS-XX	TRAFFIC SIGNAL DETAILS
XX-XX	L-01-LXX	LIGHTING PLANS
XX-XX	L-XX-LXX	LIGHTING DETAILS
41-48	PLA-01-PLA-08	PLANTING PLANS
XX-XX	PL-XX-PL-XX	PLANTING DETAILS

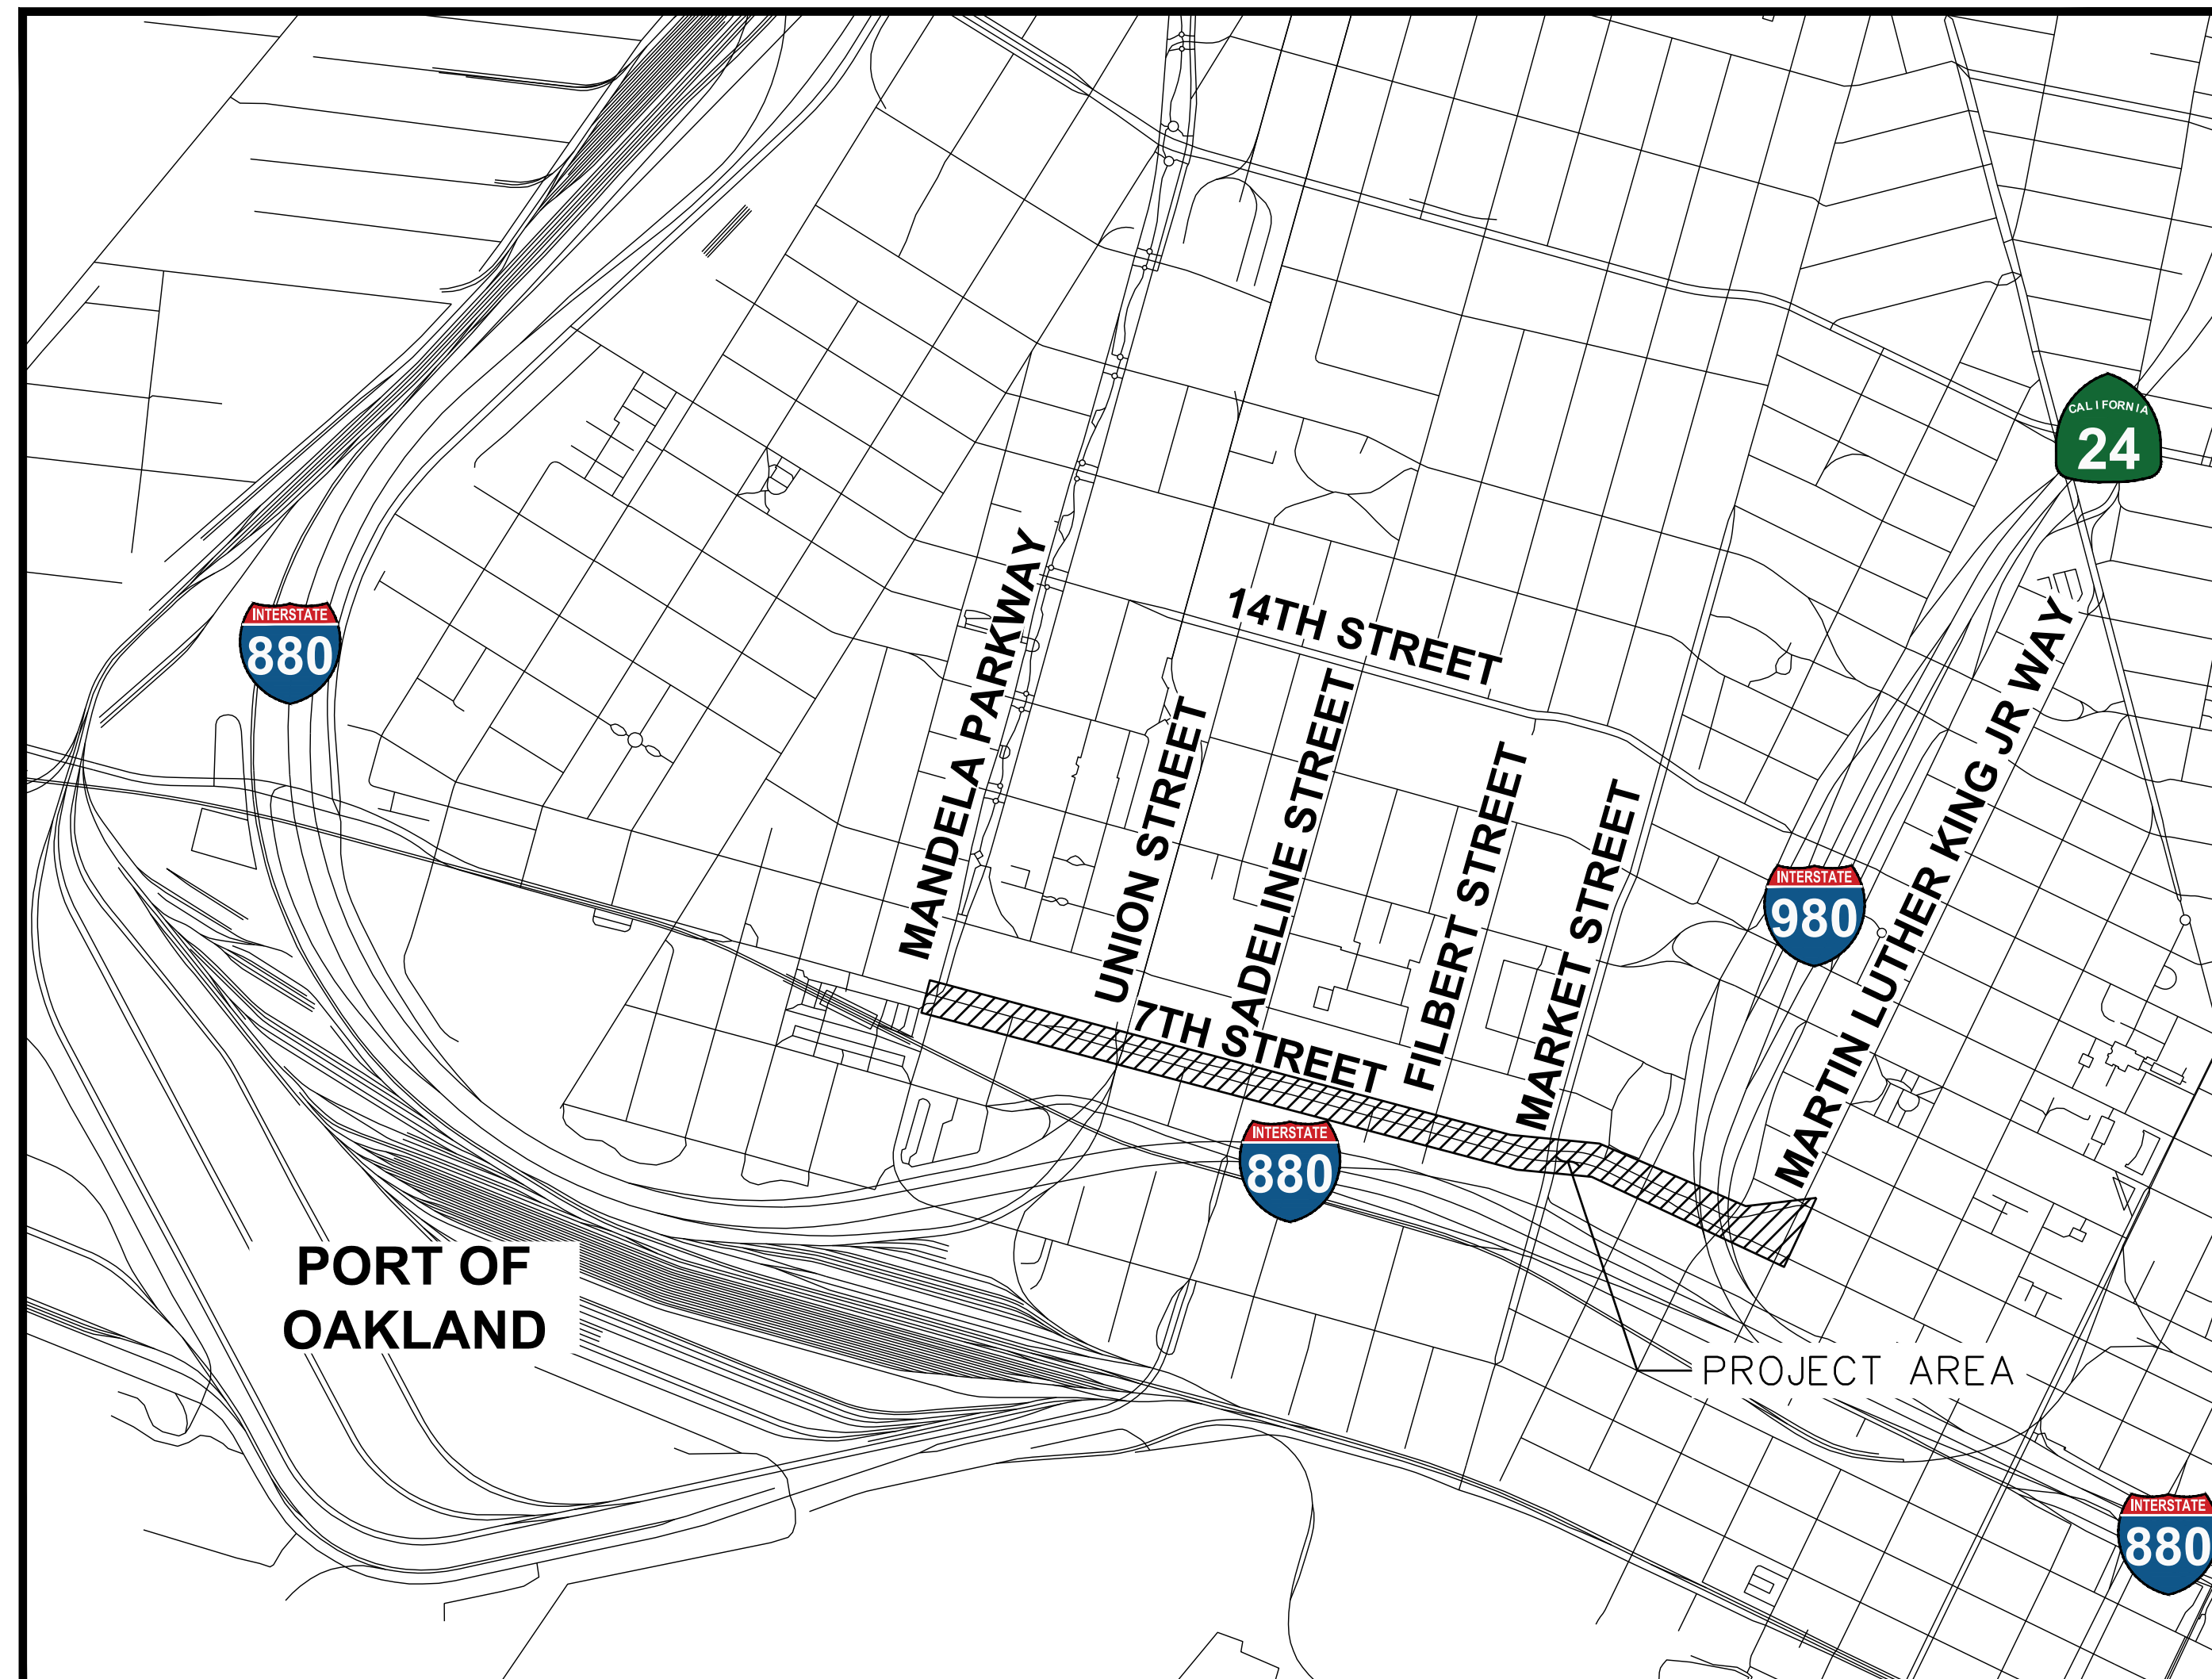



FRED KELLEY
OAKLAND DEPARTMENT OF TRANSPORTATION
ASSISTANT DIRECTOR

35% SUBMITTAL
NOT FOR BID OR CONSTRUCTION

SCALE: NTS	SHEET NO. T-01
DATE: FEB 01, 2024	1 OF 46

DRAWING NAME: N:\Shared\PROJECTS\2022\00-2022-242 oakland, ca 7th street connection project\CAD\01_Plans\2022-242-G-COV-01.dwg
PLOT DATE: 02-01-24
PLOT BY: maggiewhite

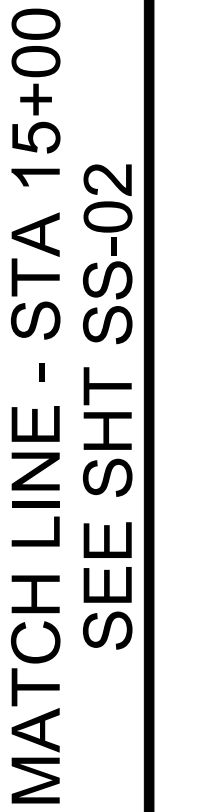

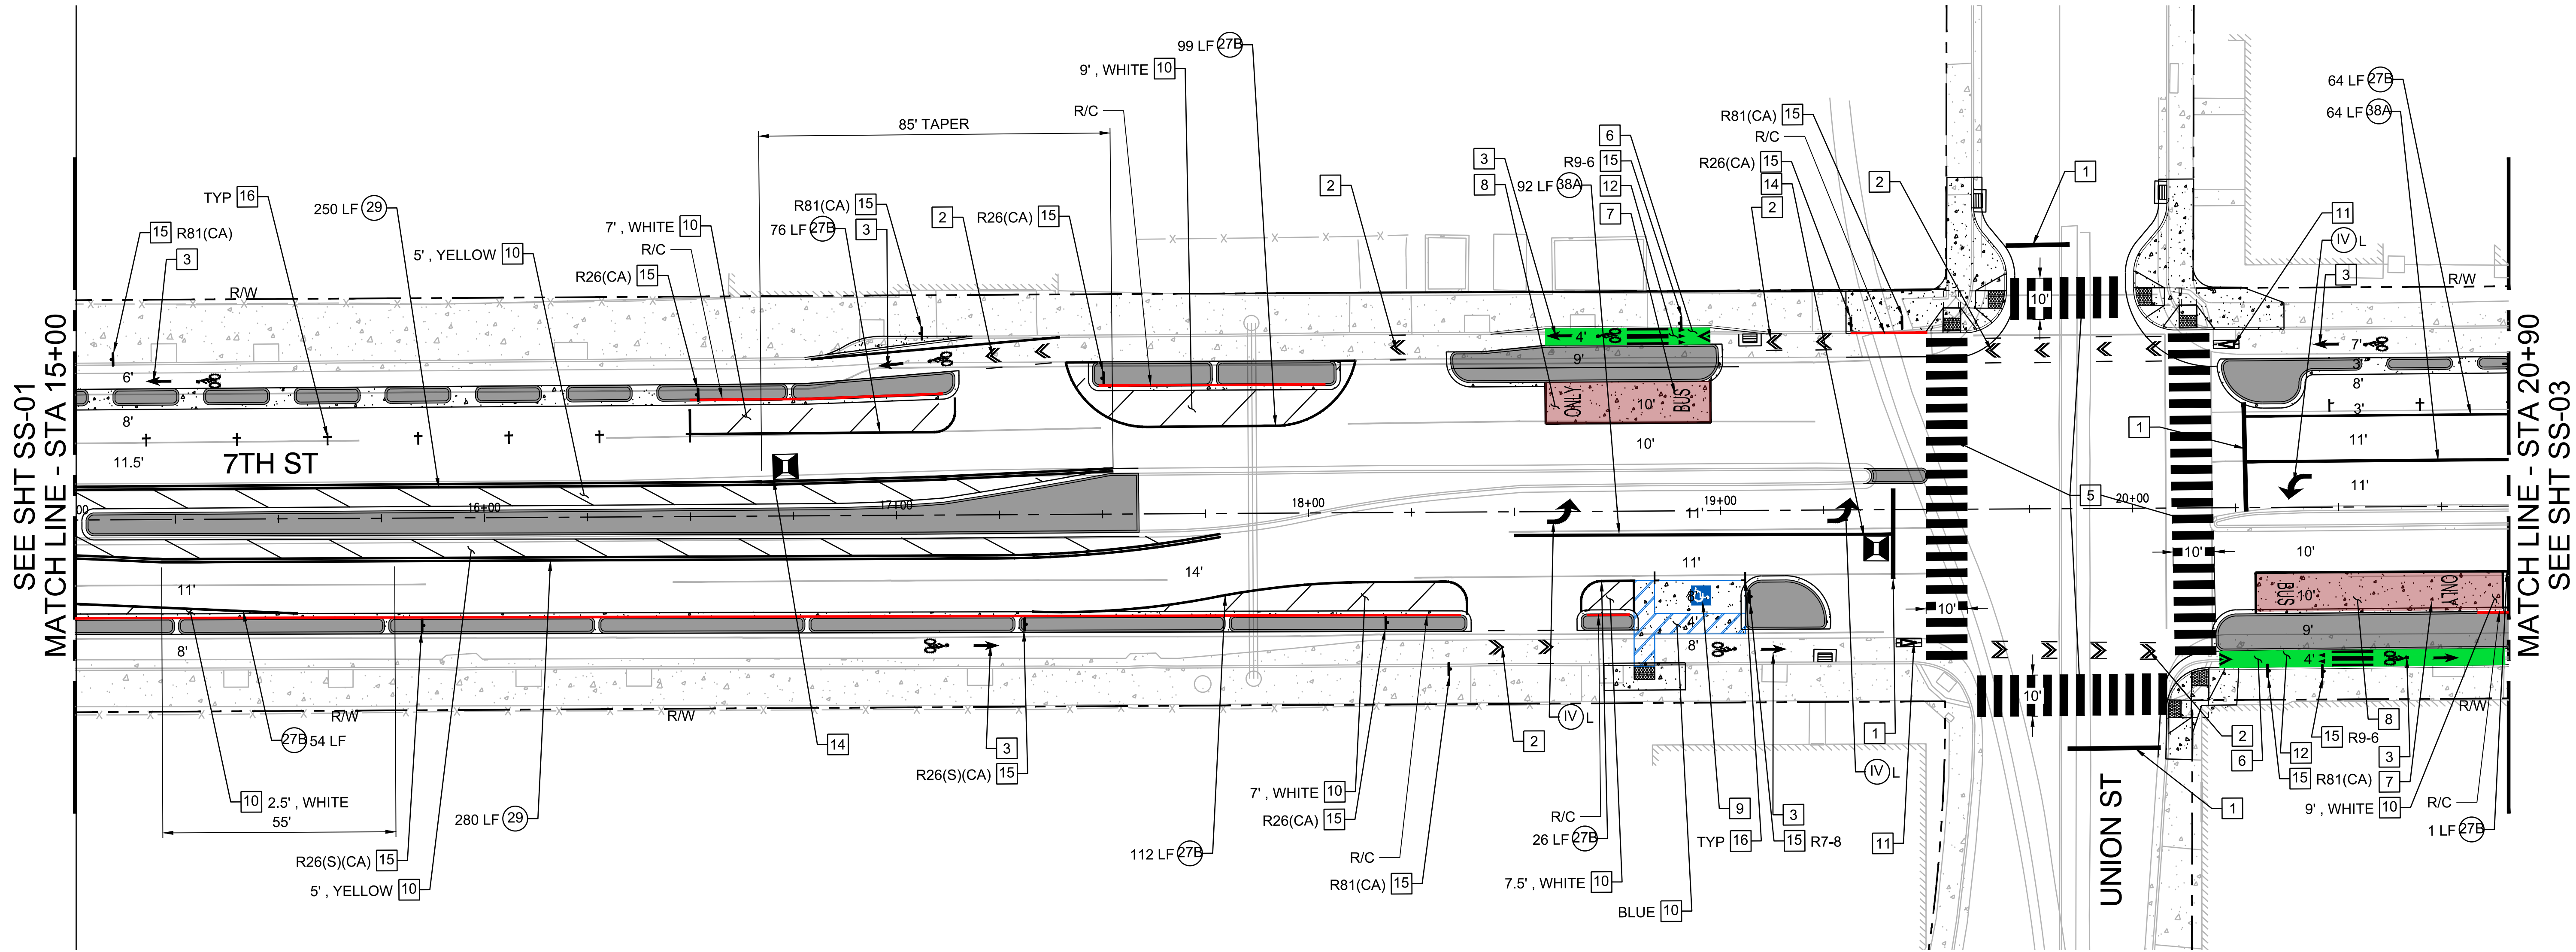

STRIPING NOTES

- XX INSTALL STRIPING DETAIL NUMBER PER CALTRANS STD. PLANS A20A - A20E

○ INSTALL ROMAN NUMERAL ARROW PAVEMENT MARKINGS PER CALTRANS STD. PLAN A24A

1 INSTALL 12" WHITE LIMIT LINE MARKINGS PER CITY DETAIL, RM-5

2 INSTALL BIKE LANE EXTENSION MARKINGS PER CITY DETAIL RM-9

3 INSTALL BIKE LANE MARKING PER CITY DETAIL RM-1

5 INSTALL HIGH VISIBILITY STYLE WHITE CROSSWALK MARKINGS PER CITY DETAIL RM-4, WIDTH PER PLANS

6 INSTALL GREEN PAVEMENT MARKING MATERIAL

7 INSTALL "BUS ONLY" MARKINGS PER DETAIL X, SHEET D-OX
- 8 INSTALL RED PAVEMENT MARKING MATERIAL

9 INSTALL BLUE INTERNATIONAL SYMBOL OF ACCESSIBILITY *ISA) MARKING PER CALTRANS STD. PLAN A24C

10 INSTALL DIAGONAL PAVEMENT STRIPING 15' ON CENTER, COLOR AND WIDTH PER PLANS

11 INSTALL BICYCLE DETECTOR PAVEMENT MARKING PER CITY DETAIL M-3


12 INSTALL SIDE BOARDING BIKE CHANNEL PER DETAIL X, SHEET D-OX

14 INSTALL FIRE HYDRANT MARKER PER DETAIL X, SHEET D0X


15 INSTALL SIGN AND POST PER CITY DETAIL SD-1

16 INSTALL PARKING STALL TEE PER CITY DETAIL RM-11

SIGN TYPE LEGEND:

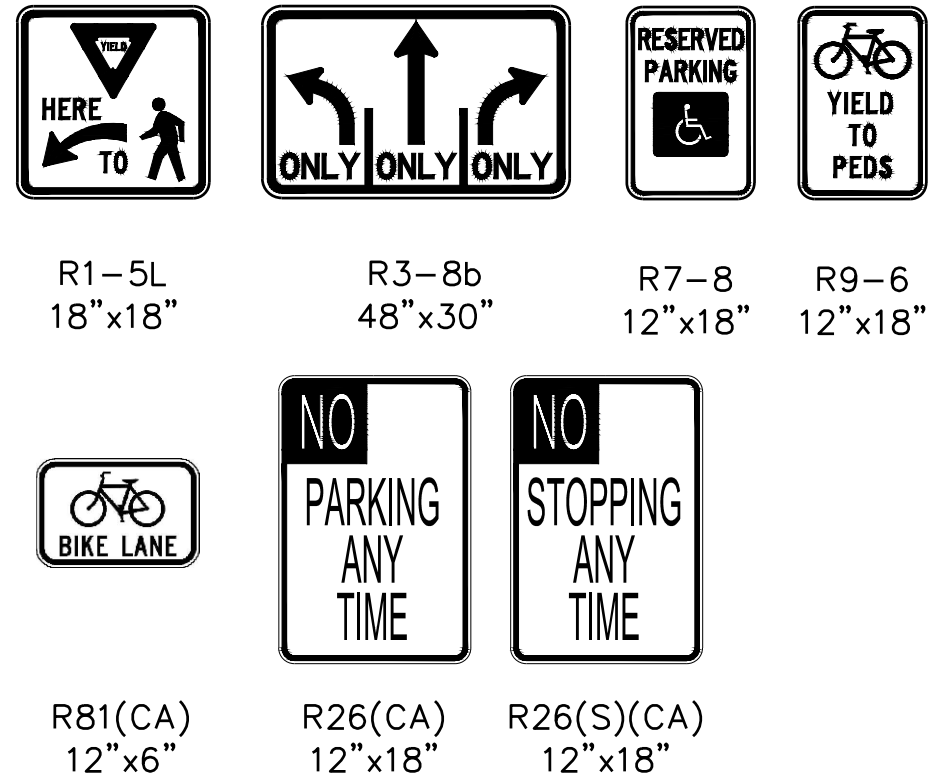


SIGNING AND STRIPING LEGEND:

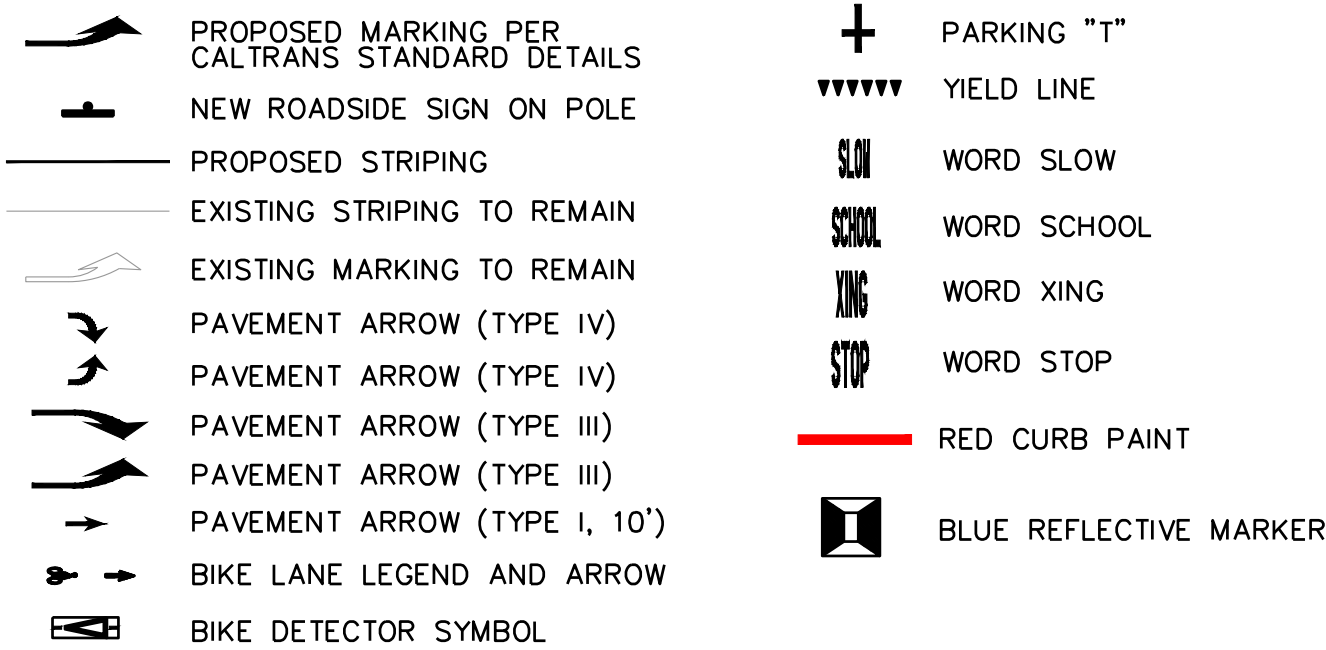

35% SUBMITTAL
NOT FOR BID OR CONSTRUCTION

7TH STREET CONNECTION

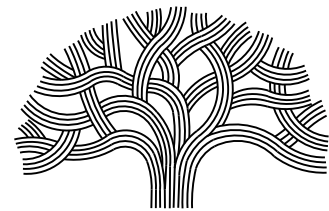

CITY OF OAKLAND

DEPARTMENT OF TRANSPORTATION
250 FRANK H. OGAWA PLAZA, SUITE 4314 * OAKLAND CA, 94612
(510) 238-3437 * FAX (510) 238-7227

CIVIL ENGINEER
THOMAS NATWICK

RCE NO. C78770

CHECKED BY VH


DESIGNED BY MW

DRAWN BY MW

NO.	DATE	BY	REFERENCE

SIGNING AND STRIPING
PLAN


BAR IS ONE INCH ON ORIGINAL SIZE SHEET
IF NOT ONE INCH ON THIS SHEET, ADJUST SCALES ACCORDINGLY

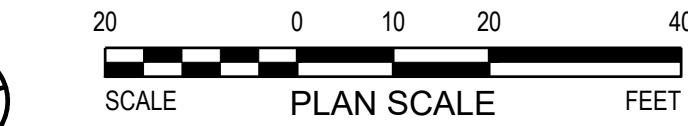

PROJECT NO.
1006182


SHEET NO.
SS-02

DATE: 2/1/2024
32 OF 46

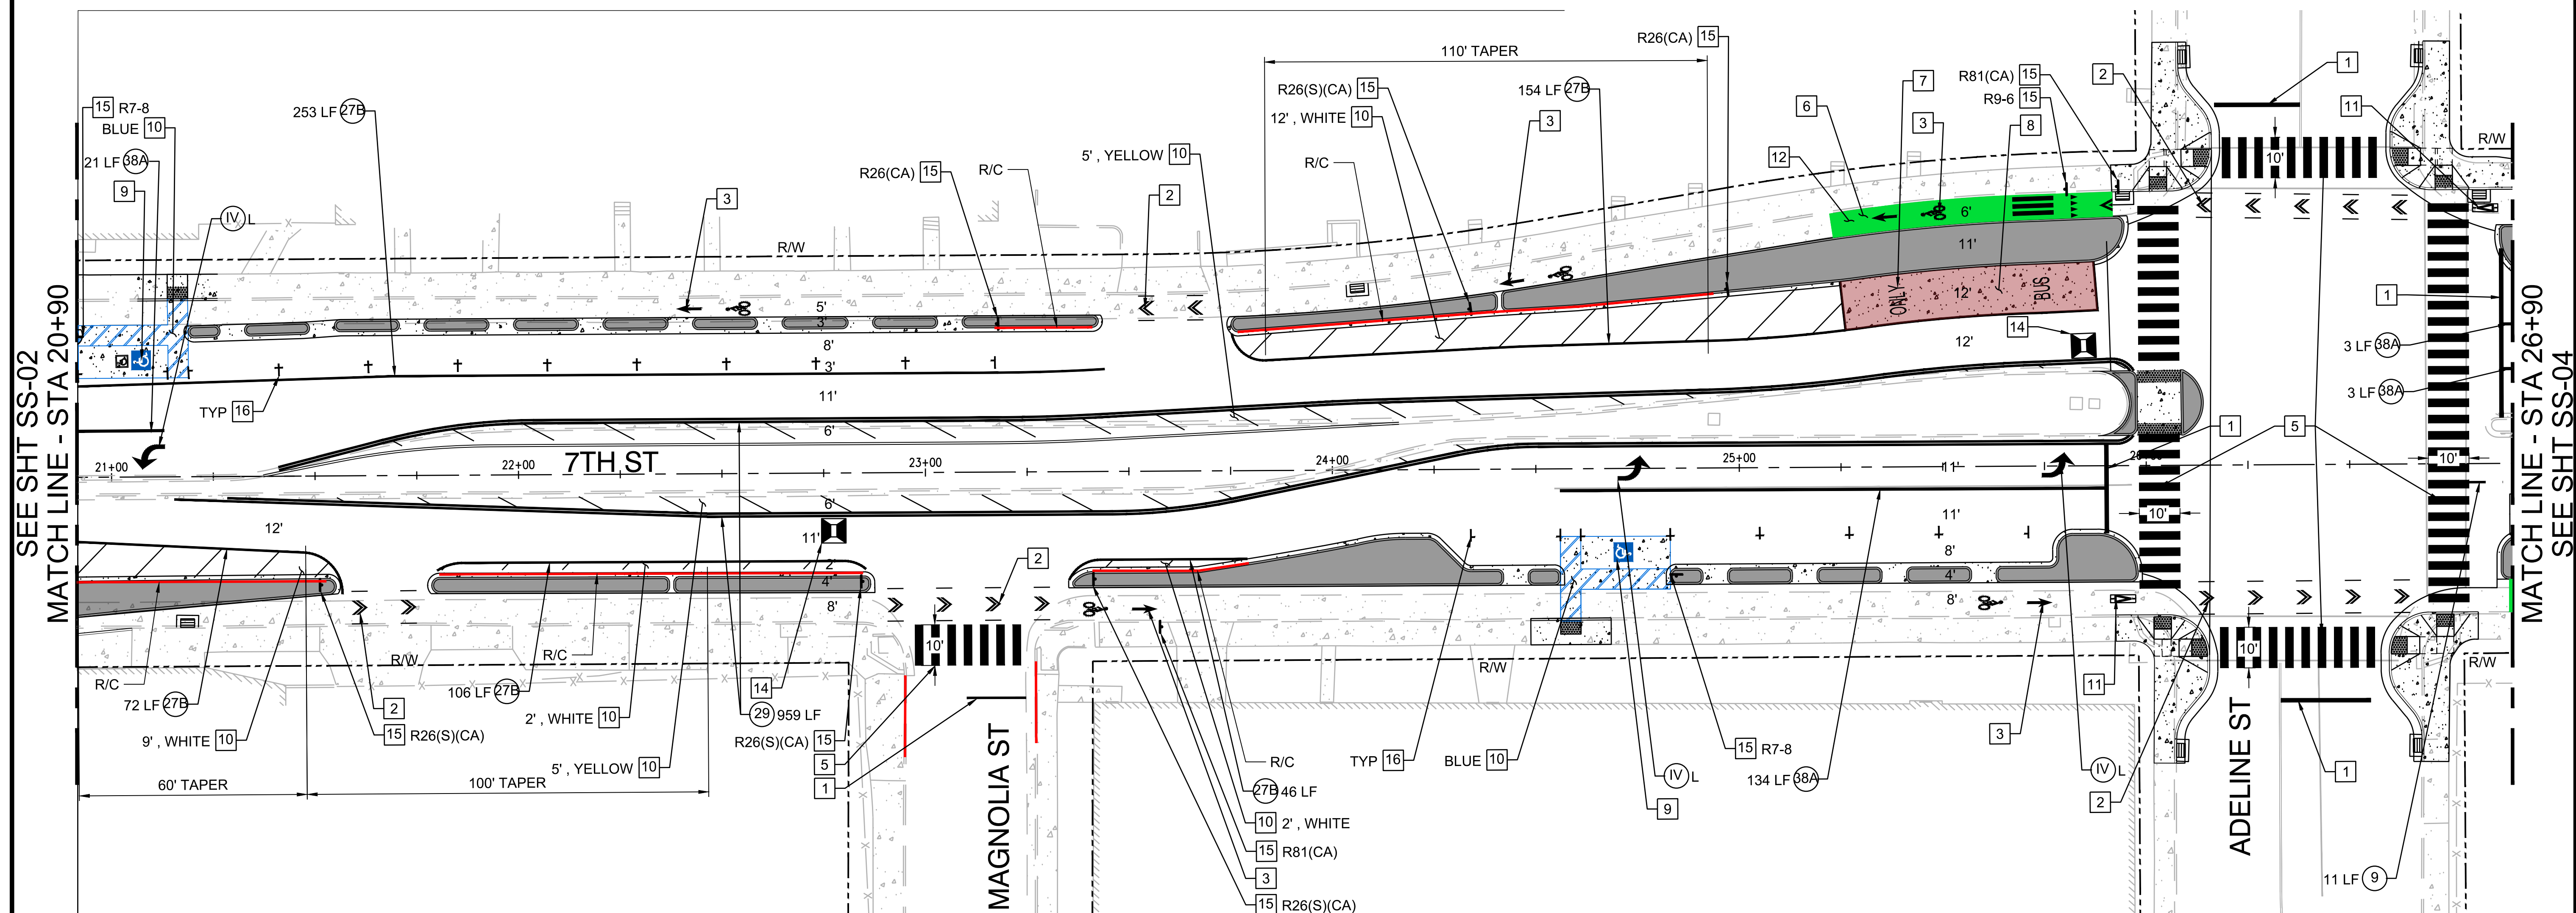

STRIPING NOTES

- | | |
|--|-------------|
| | PROJECT NO. |
|--|-------------|

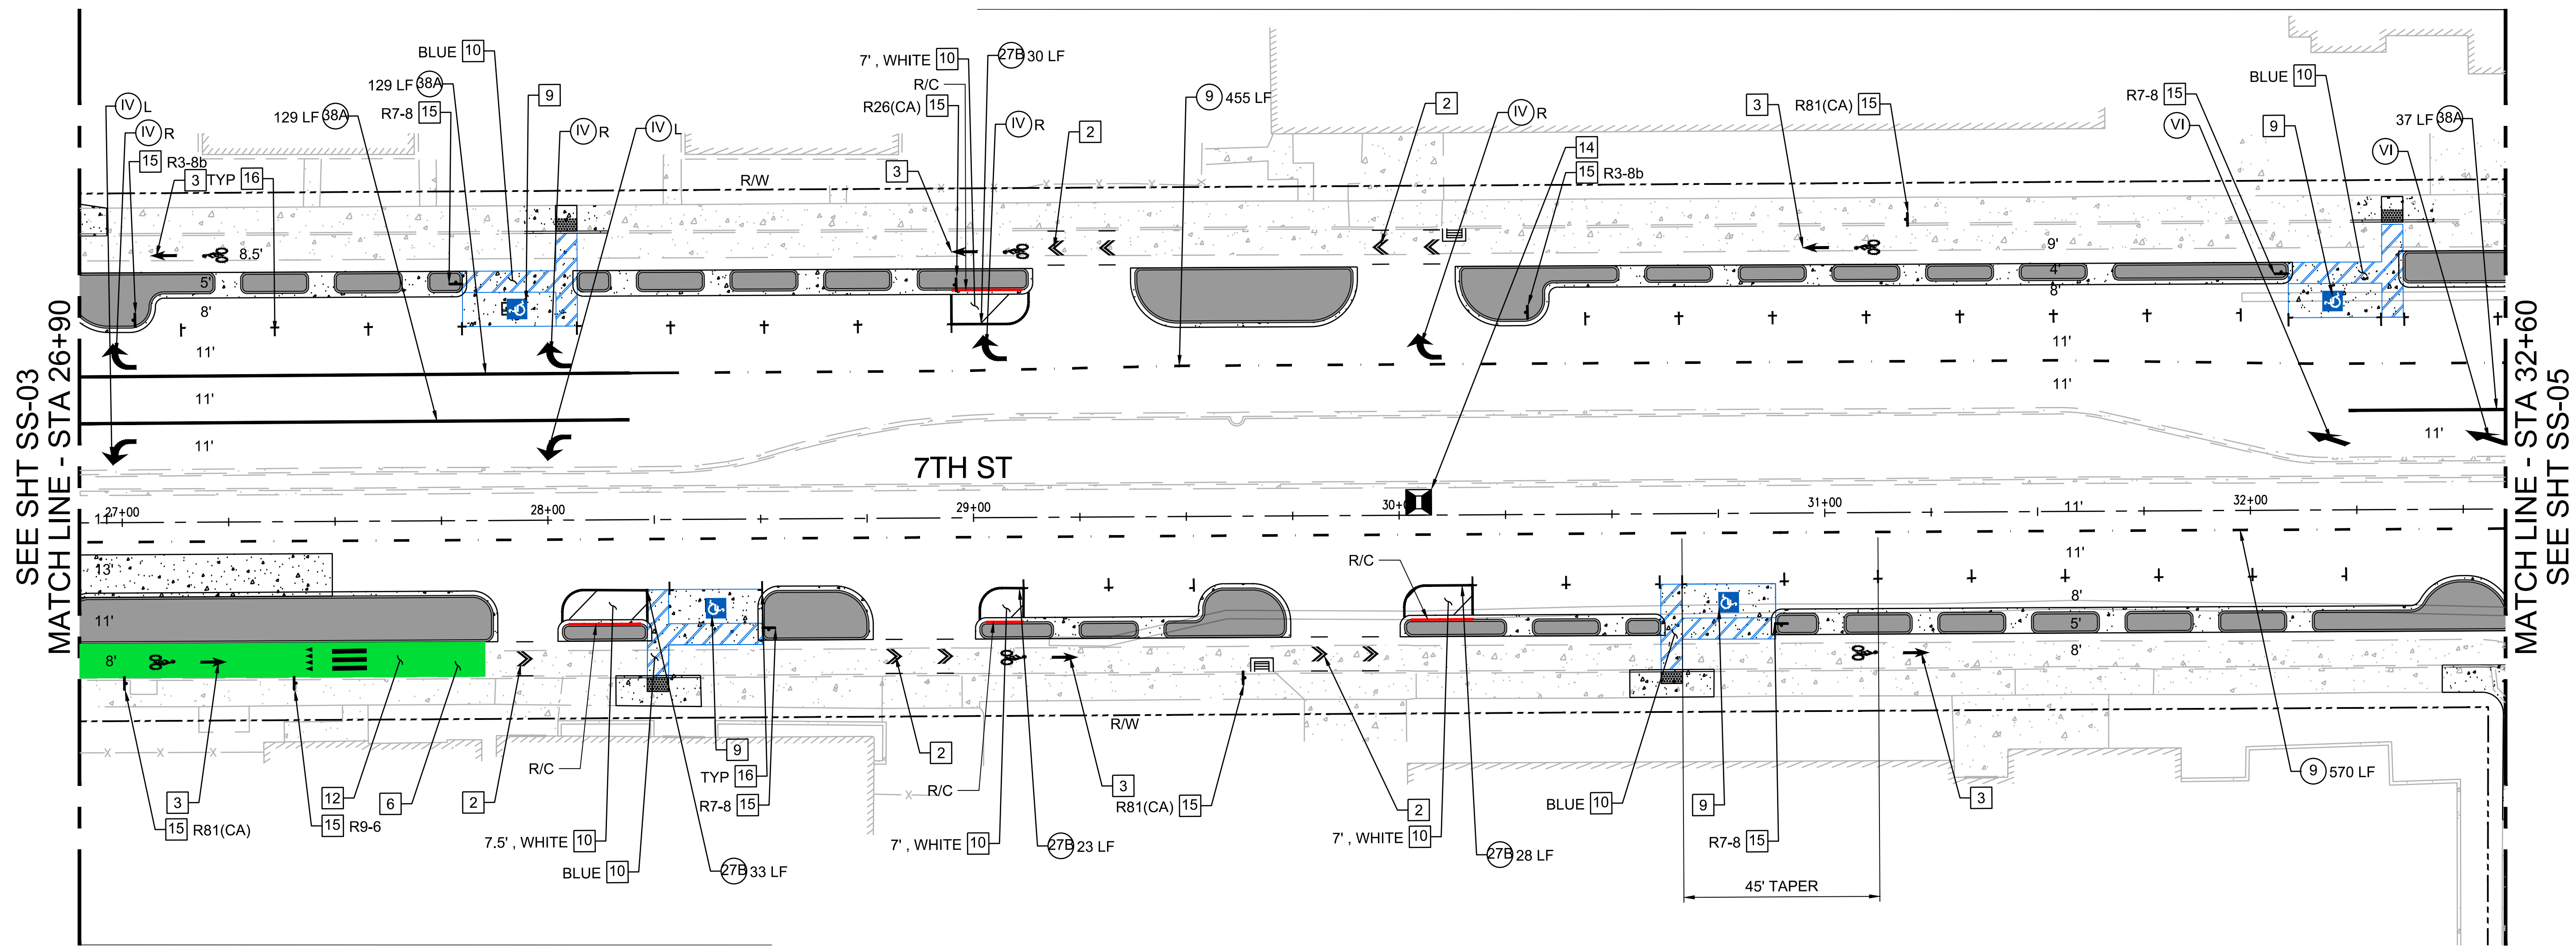

STRIPING NOTES

- XX INSTALL STRIPING DETAIL NUMBER PER CALTRANS STD. PLANS A20A - A20E
- INSTALL ROMAN NUMERAL ARROW PAVEMENT MARKINGS PER CALTRANS STD. PLAN A24A
- 1 INSTALL 12" WHITE LIMIT LINE MARKINGS PER CITY DETAIL, RM-5
- 2 INSTALL BIKE LANE EXTENSION MARKINGS PER CITY DETAIL RM-9
- 3 INSTALL BIKE LANE MARKING PER CITY DETAIL RM-1
- 6 INSTALL GREEN PAVEMENT MARKING MATERIAL
- 9 INSTALL BLUE INTERNATIONAL SYMBOL OF ACCESSIBILITY *ISA) MARKING PER CALTRANS STD. PLAN A24C
- 10 INSTALL DIAGONAL PAVEMENT STRIPING 15' ON CENTER, COLOR AND WIDTH PER PLANS
- 11 INSTALL BICYCLE DETECTOR PAVEMENT MARKING PER CITY DETAIL M-3
- 12 INSTALL SIDE BOARDING BIKE CHANNEL PER DETAIL X, SHEET D-0X
- 14 INSTALL FIRE HYDRANT MARKER PER DETAIL X, SHEET D0X
- 15 INSTALL SIGN AND POST PER CITY DETAIL SD-1
- 16 INSTALL PARKING STALL TEE PER CITY DETAIL RM-11

SIGN TYPE LEGEND:

Sign type legend showing various signs and their dimensions:

- R1-5L 18"x18"
- R3-8b 48"x30"
- R7-8 12"x18"
- R9-6 12"x18"
- R81(CA) 12"x6"
- R26(CA) 12"x18"
- R26(S)(CA) 12"x18"


SIGNING AND STRIPING LEGEND:

Signing and striping legend showing various markings and their meanings:

- PROPOSED MARKING PER CALTRANS STANDARD DETAILS
- NEW ROADSIDE SIGN ON POLE
- PROPOSED STRIPING
- EXISTING STRIPING TO REMAIN
- EXISTING MARKING TO REMAIN
- PAVEMENT ARROW (TYPE IV)
- PAVEMENT ARROW (TYPE IV)
- PAVEMENT ARROW (TYPE III)
- PAVEMENT ARROW (TYPE III)
- PAVEMENT ARROW (TYPE I, 10')
- BIKE LANE LEGEND AND ARROW
- BIKE DETECTOR SYMBOL
- PARKING "T"
- YIELD LINE
- WORD SLOW
- WORD SCHOOL
- WORD XING
- WORD STOP
- RED CURB PAINT
- BLUE REFLECTIVE MARKER

35% SUBMITTAL
NOT FOR BID OR CONSTRUCTION

7TH STREET CONNECTION

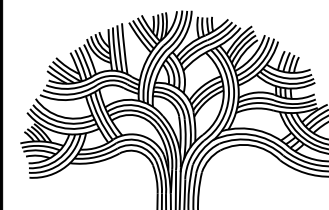

CITY OF OAKLAND

DEPARTMENT OF TRANSPORTATION
250 FRANK H. OGAWA PLAZA, SUITE 4314 * OAKLAND CA, 94612
(510) 238-3437 * FAX (510) 238-7227

CIVIL ENGINEER
THOMAS NATWICK

RCE NO. C78770

CHECKED BY VH

DESIGNED BY MW

DRAWN BY MW

NO.	DATE	BY	REFERENCE

SIGNING AND STRIPING
PLAN

BAR IS ONE INCH ON ORIGINAL SIZE SHEET
IF NOT ONE INCH ON THIS SHEET, ADJUST SCALES ACCORDINGLY

ORIGINAL SIZE
ANSI D

PROJECT NO.

1006182


SCALE:
AS SHOWN

DATE:
2/1/2024

SHEET NO.


SS-04

34 OF 46

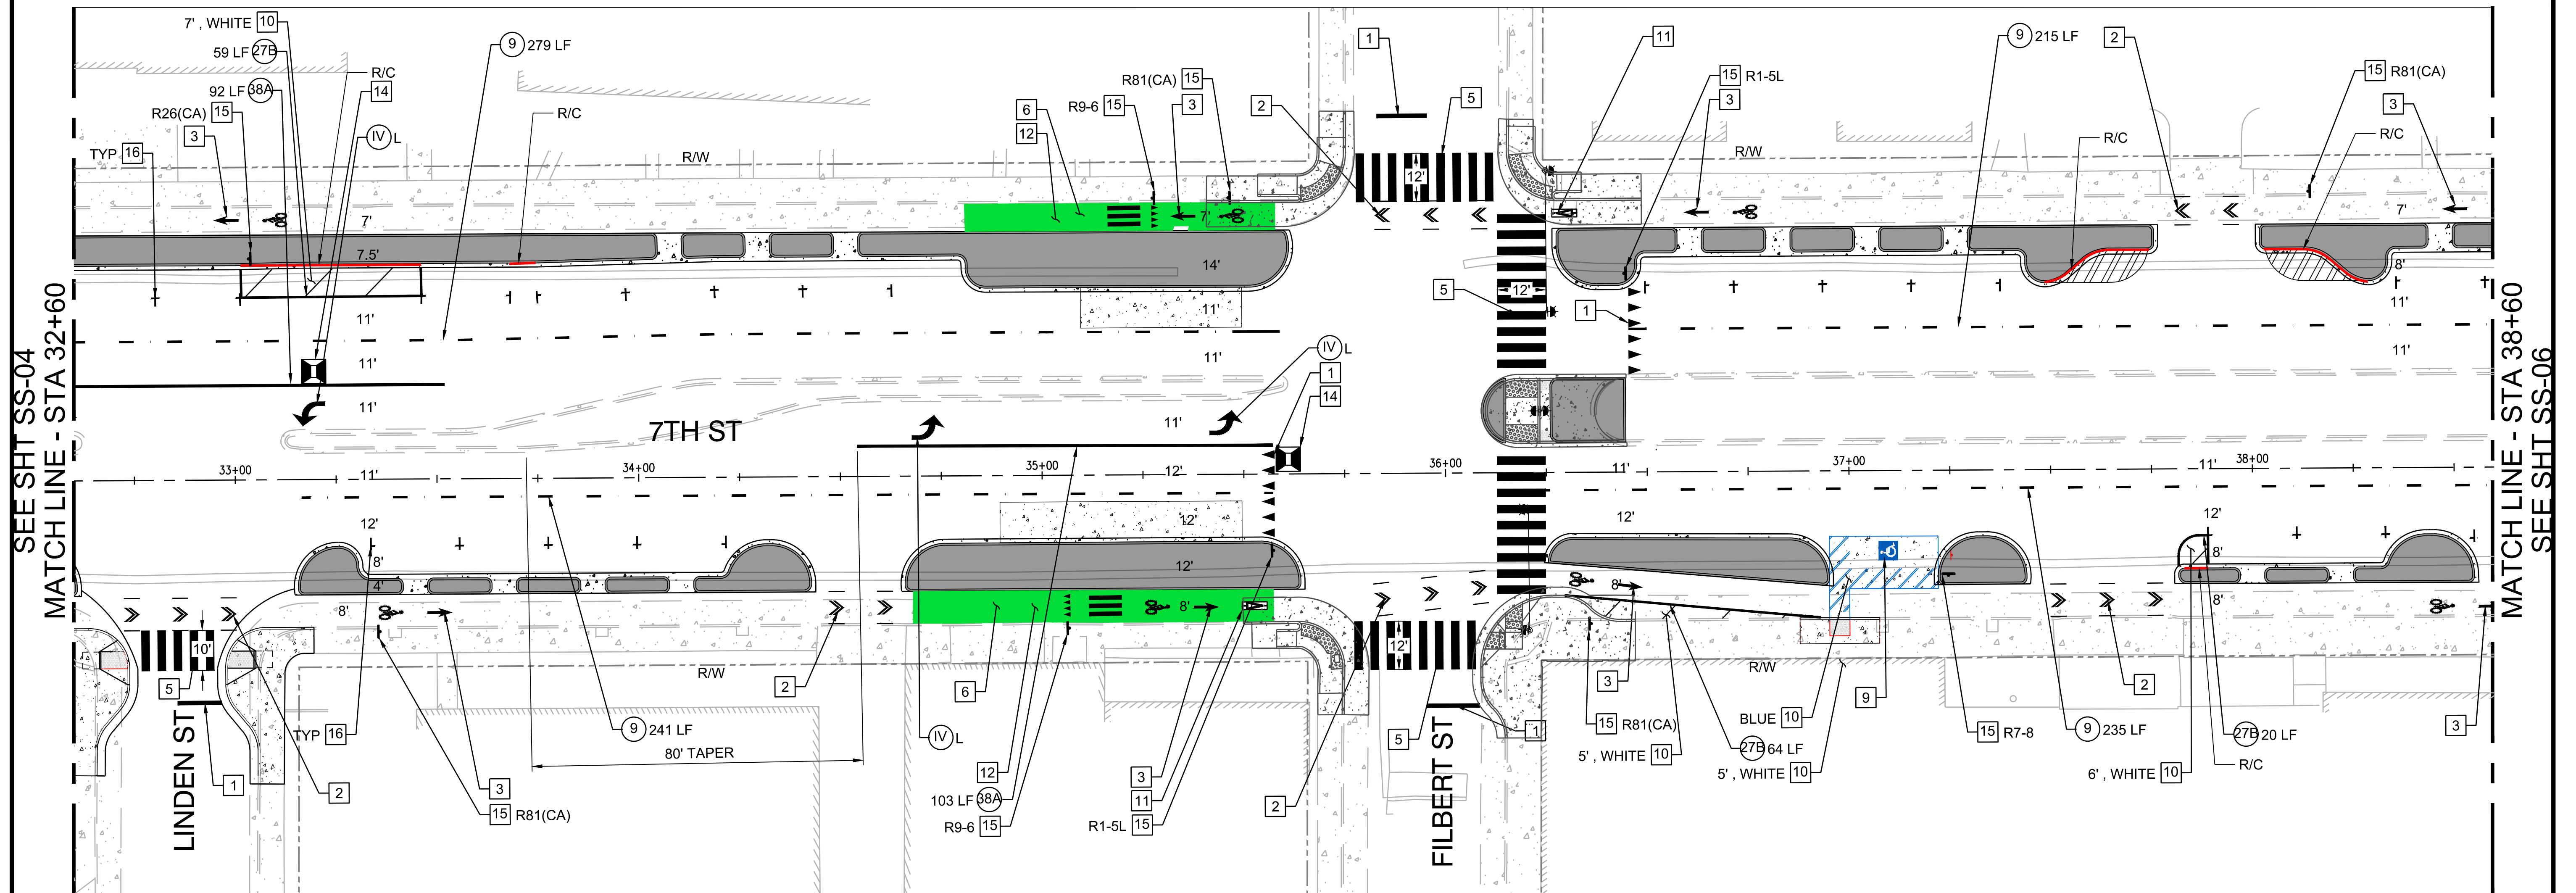

STRIPING NOTES


- | | |
|----|--|
| 9 | INSTALL BLUE INTERNATIONAL SYMBOL OF ACCESSIBILITY (ISA) MARKING PER CALTRANS STD. PLAN A24C |
| 10 | INSTALL DIAGONAL PAVEMENT STRIPING 15' ON CENTER, COLOR AND WIDTH PER PLANS |
| 11 | INSTALL BICYCLE DETECTOR PAVEMENT MARKING PER CITY DETAIL M-3 |
| 12 | INSTALL SIDE BOARDING BIKE CHANNEL PER DETAIL X, SHEET D-0X |
| 14 | INSTALL FIRE HYDRANT MARKER PER DETAIL X, SHEET D0X |
| 15 | INSTALL SIGN AND POST PER CITY DETAIL SD-1 |
| 16 | INSTALL PARKING STALL TEE PER CITY DETAIL RM-11 |

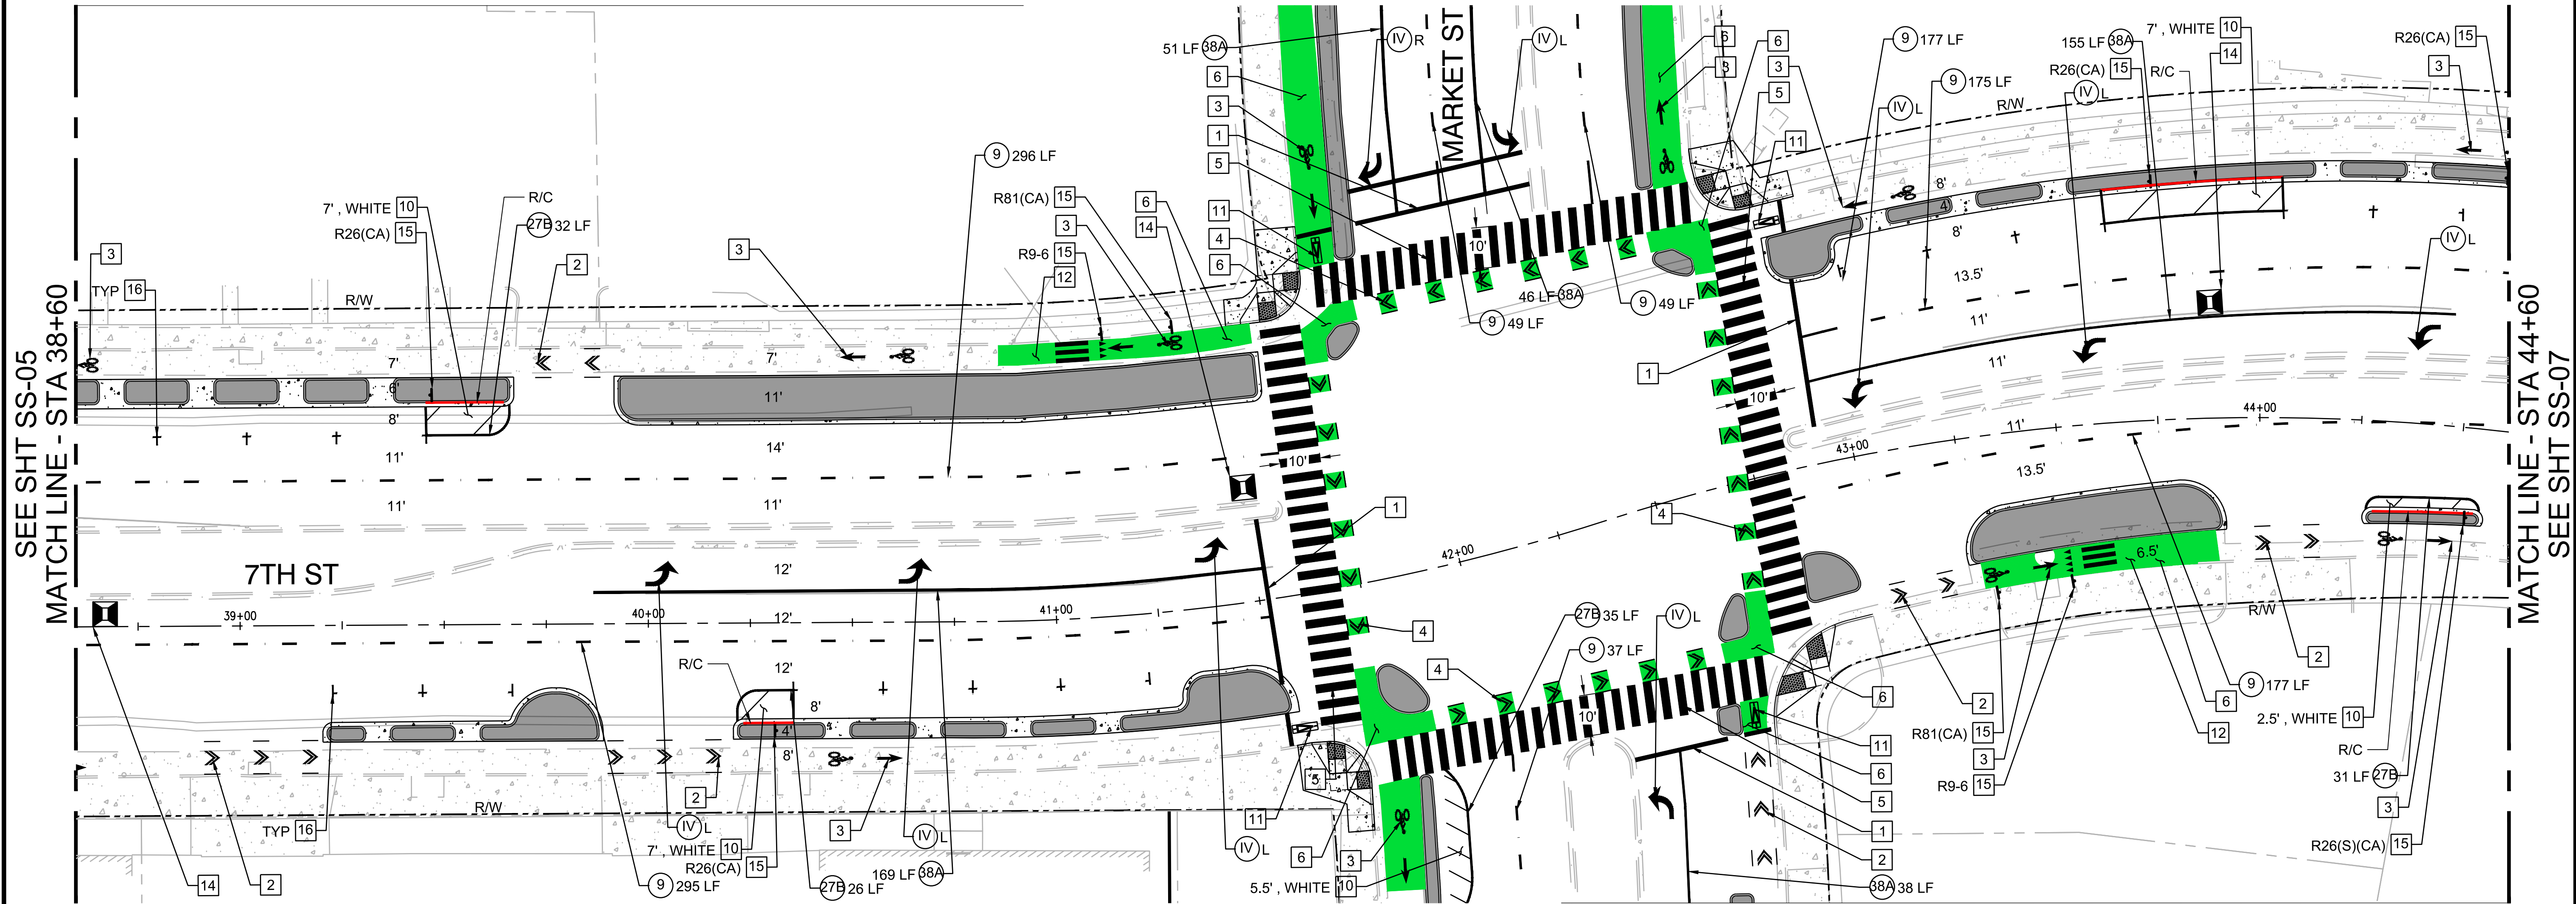


STRIPING NOTES

- XX INSTALL STRIPING DETAIL NUMBER PER CALTRANS STD. PLANS A20A - A20E
- INSTALL ROMAN NUMERAL ARROW PAVEMENT MARKINGS PER CALTRANS STD. PLAN A24A
- 1 INSTALL 12" WHITE LIMIT LINE MARKINGS PER CITY DETAIL, RM-5
- 2 INSTALL BIKE LANE EXTENSION MARKINGS PER CITY DETAIL RM-9
- 3 INSTALL BIKE LANE MARKING PER CITY DETAIL RM-1
- 4 INSTALL BIKE LANE INTERSECTION MARKING PER CITY DETAIL GB-4
- 5 INSTALL HIGH VISIBILITY STYLE WHITE CROSSWALK MARKINGS PER CITY DETAIL RM-4, WIDTH PER PLANS
- 6 INSTALL GREEN PAVEMENT MARKING MATERIAL
- 10 INSTALL DIAGONAL PAVEMENT STRIPING 15' ON CENTER, COLOR AND WIDTH PER PLANS
- 11 INSTALL BICYCLE DETECTOR PAVEMENT MARKING PER CITY DETAIL M-3
- 12 INSTALL SIDE BOARDING BIKE CHANNEL PER DETAIL X, SHEET D-0X
- 14 INSTALL FIRE HYDRANT MARKER PER DETAIL X, SHEET D0X
- 15 INSTALL SIGN AND POST PER CITY DETAIL SD-1
- 16 INSTALL PARKING STALL TEE PER CITY DETAIL RM-11

SIGN TYPE LEGEND:

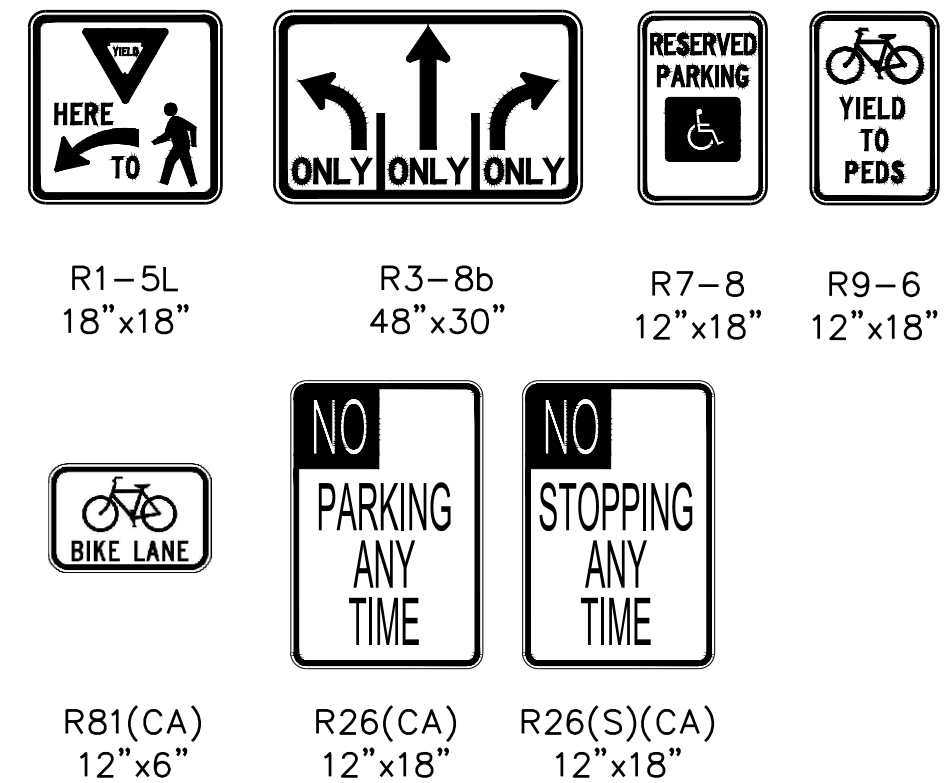


SIGNING AND STRIPING LEGEND:

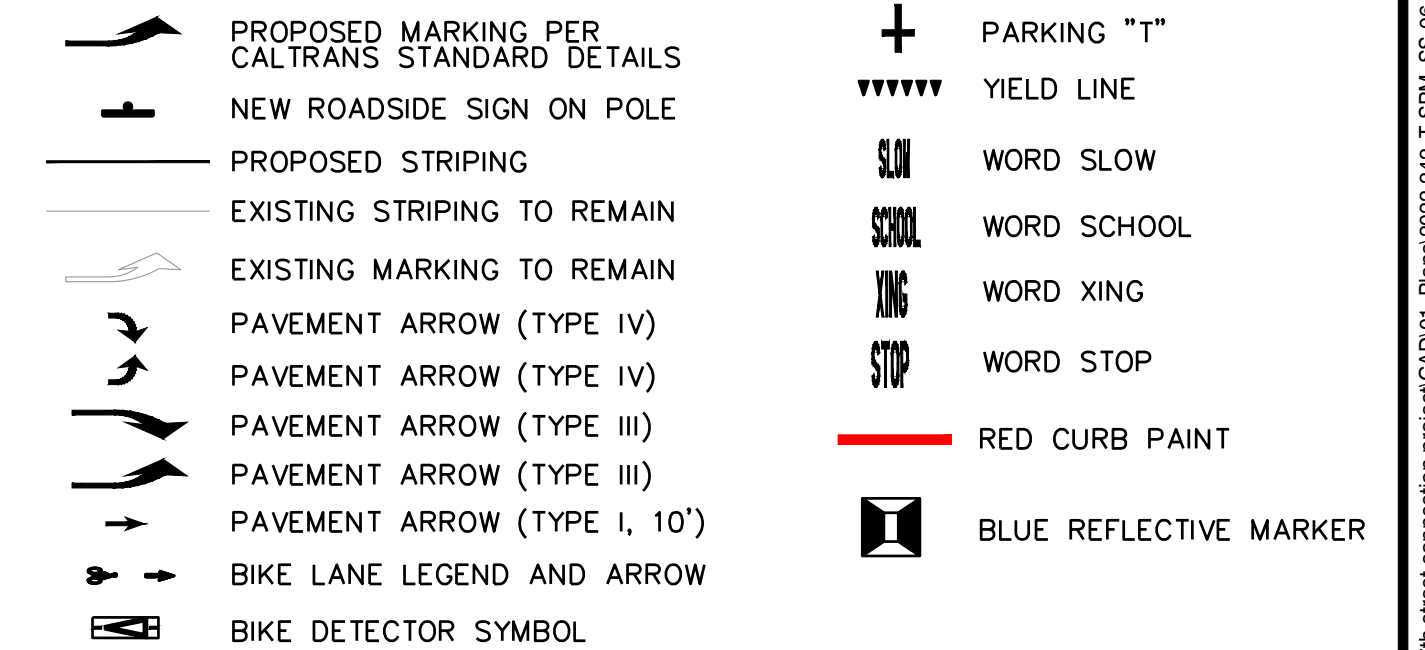

35% SUBMITTAL
NOT FOR BID OR CONSTRUCTION

7TH STREET CONNECTION

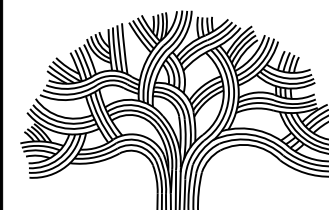

CITY OF OAKLAND

DEPARTMENT OF TRANSPORTATION
250 FRANK H. OGAWA PLAZA, SUITE 4314 * OAKLAND CA, 94612
(510) 238-3437 * FAX (510) 238-7227

CIVIL ENGINEER
THOMAS NATWICK

RCE NO. C78770

CHECKED BY VH

DESIGNED BY MW

DRAWN BY MW

NO.	DATE	BY	REFERENCE

SIGNING AND STRIPING PLAN

BAR IS ONE INCH ON ORIGINAL SIZE SHEET
IF NOT ONE INCH ON THIS SHEET, ADJUST SCALES ACCORDINGLY

ORIGINAL SIZE
ANSI D

PROJECT NO.

1006182


SCALE:
AS SHOWN

DATE:
2/1/2024

SHEET NO.

SS-06

36 OF 46

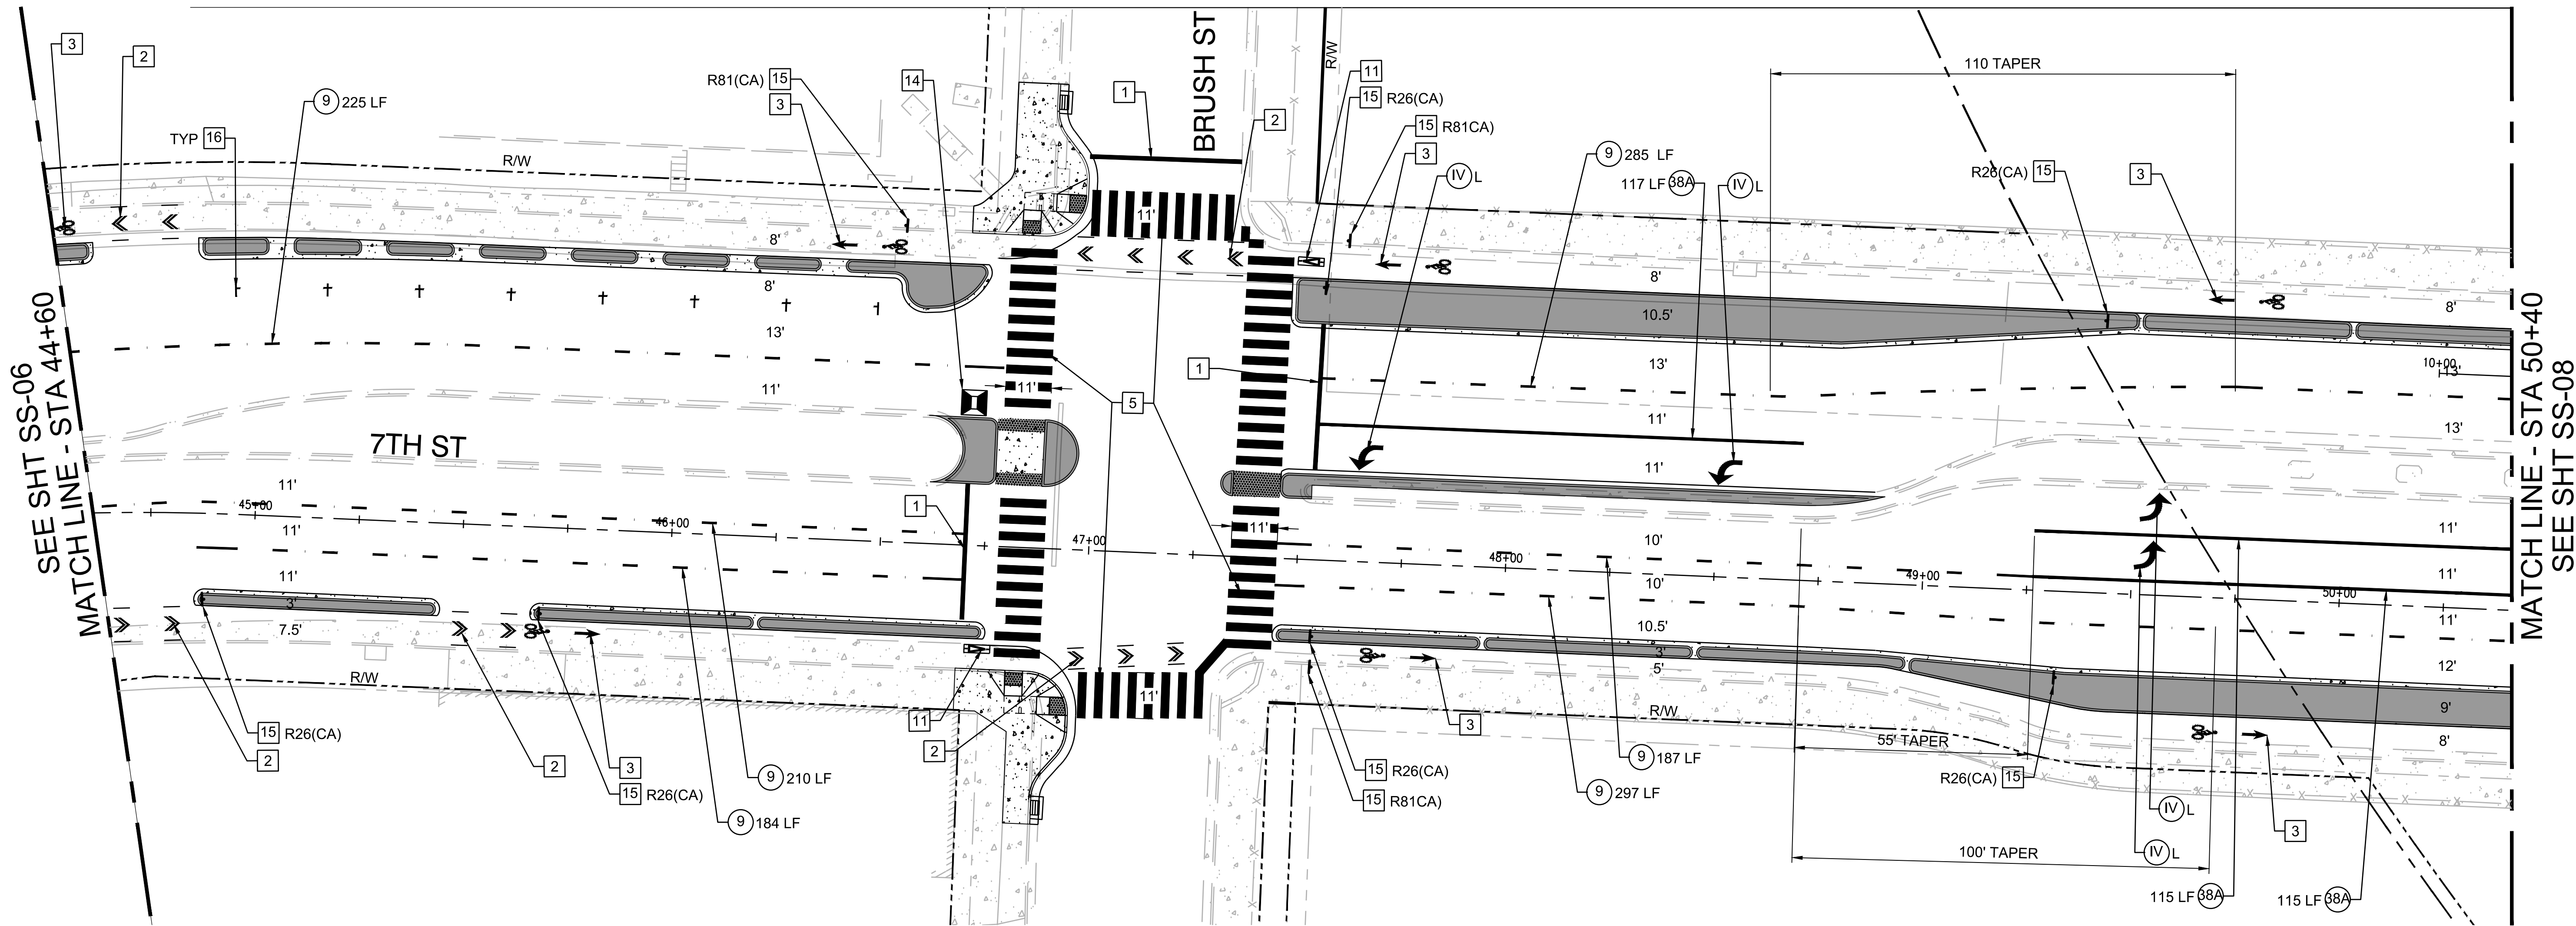

STRIPING NOTES

- XX INSTALL STRIPING DETAIL NUMBER PER CALTRANS STD. PLANS A20A - A20E
- INSTALL ROMAN NUMERAL ARROW PAVEMENT MARKINGS PER CALTRANS STD. PLAN A24A
- 1 INSTALL 12" WHITE LIMIT LINE MARKINGS PER CITY DETAIL, RM-5
- 2 INSTALL BIKE LANE EXTENSION MARKINGS PER CITY DETAIL RM-9
- 3 INSTALL BIKE LANE MARKING PER CITY DETAIL RM-1
- 5 INSTALL HIGH VISIBILITY STYLE WHITE CROSSWALK MARKINGS PER CITY DETAIL RM-4, WIDTH PER PLANS
- 11 INSTALL BICYCLE DETECTOR PAVEMENT MARKING PER CITY DETAIL M-3
- 14 INSTALL FIRE HYDRANT MARKER PER DETAIL X, SHEET D0X
- 15 INSTALL SIGN AND POST PER CITY DETAIL SD-1
- 16 INSTALL PARKING STALL TEE PER CITY DETAIL RM-11

SIGN TYPE LEGEND:

R1-5L 18"x18" R3-8b 48"x30" R7-8 12"x18" R9-6 12"x18"

R81(CA) 12"x6" R26(CA) 12"x18" R26(S)(CA) 12"x18"

SIGNING AND STRIPING LEGEND:

PROPOSED MARKING PER CALTRANS STANDARD DETAILS

NEW ROADSIDE SIGN ON POLE

PROPOSED STRIPING

EXISTING STRIPING TO REMAIN

EXISTING MARKING TO REMAIN

PAVEMENT ARROW (TYPE IV)

PAVEMENT ARROW (TYPE IV)

PAVEMENT ARROW (TYPE III)

PAVEMENT ARROW (TYPE III)

PAVEMENT ARROW (TYPE I, 10')

BIKE LANE LEGEND AND ARROW

BIKE DETECTOR SYMBOL

PARKING "T"

YIELD LINE

WORD SLOW

WORD SCHOOL

WORD XING


WORD STOP

RED CURB PAINT

BLUE REFLECTIVE MARKER

35% SUBMITTAL
NOT FOR BID OR CONSTRUCTION

7TH STREET CONNECTION

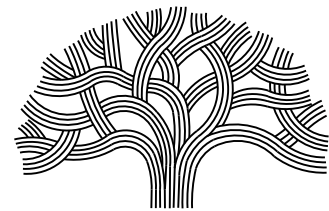

CITY OF OAKLAND

DEPARTMENT OF TRANSPORTATION
250 FRANK H. OGAWA PLAZA, SUITE 4314 * OAKLAND CA, 94612
(510) 238-3437 * FAX (510) 238-7227

CIVIL ENGINEER
THOMAS NATWICK

RCE NO. C78770

CHECKED BY VH


DESIGNED BY MW

DRAWN BY MW

NO.	DATE	BY	REFERENCE

SIGNING AND STRIPING
PLANS


BAR IS ONE INCH ON ORIGINAL SIZE SHEET
IF NOT ONE INCH ON THIS SHEET, ADJUST SCALES ACCORDINGLY

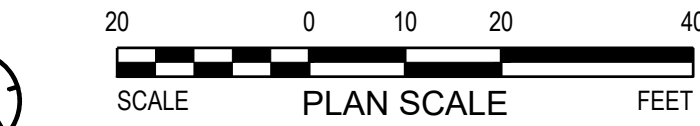

PROJECT NO.
1006182

SHEET NO.
SS-07

DATE: 2/1/2024
37 OF 46

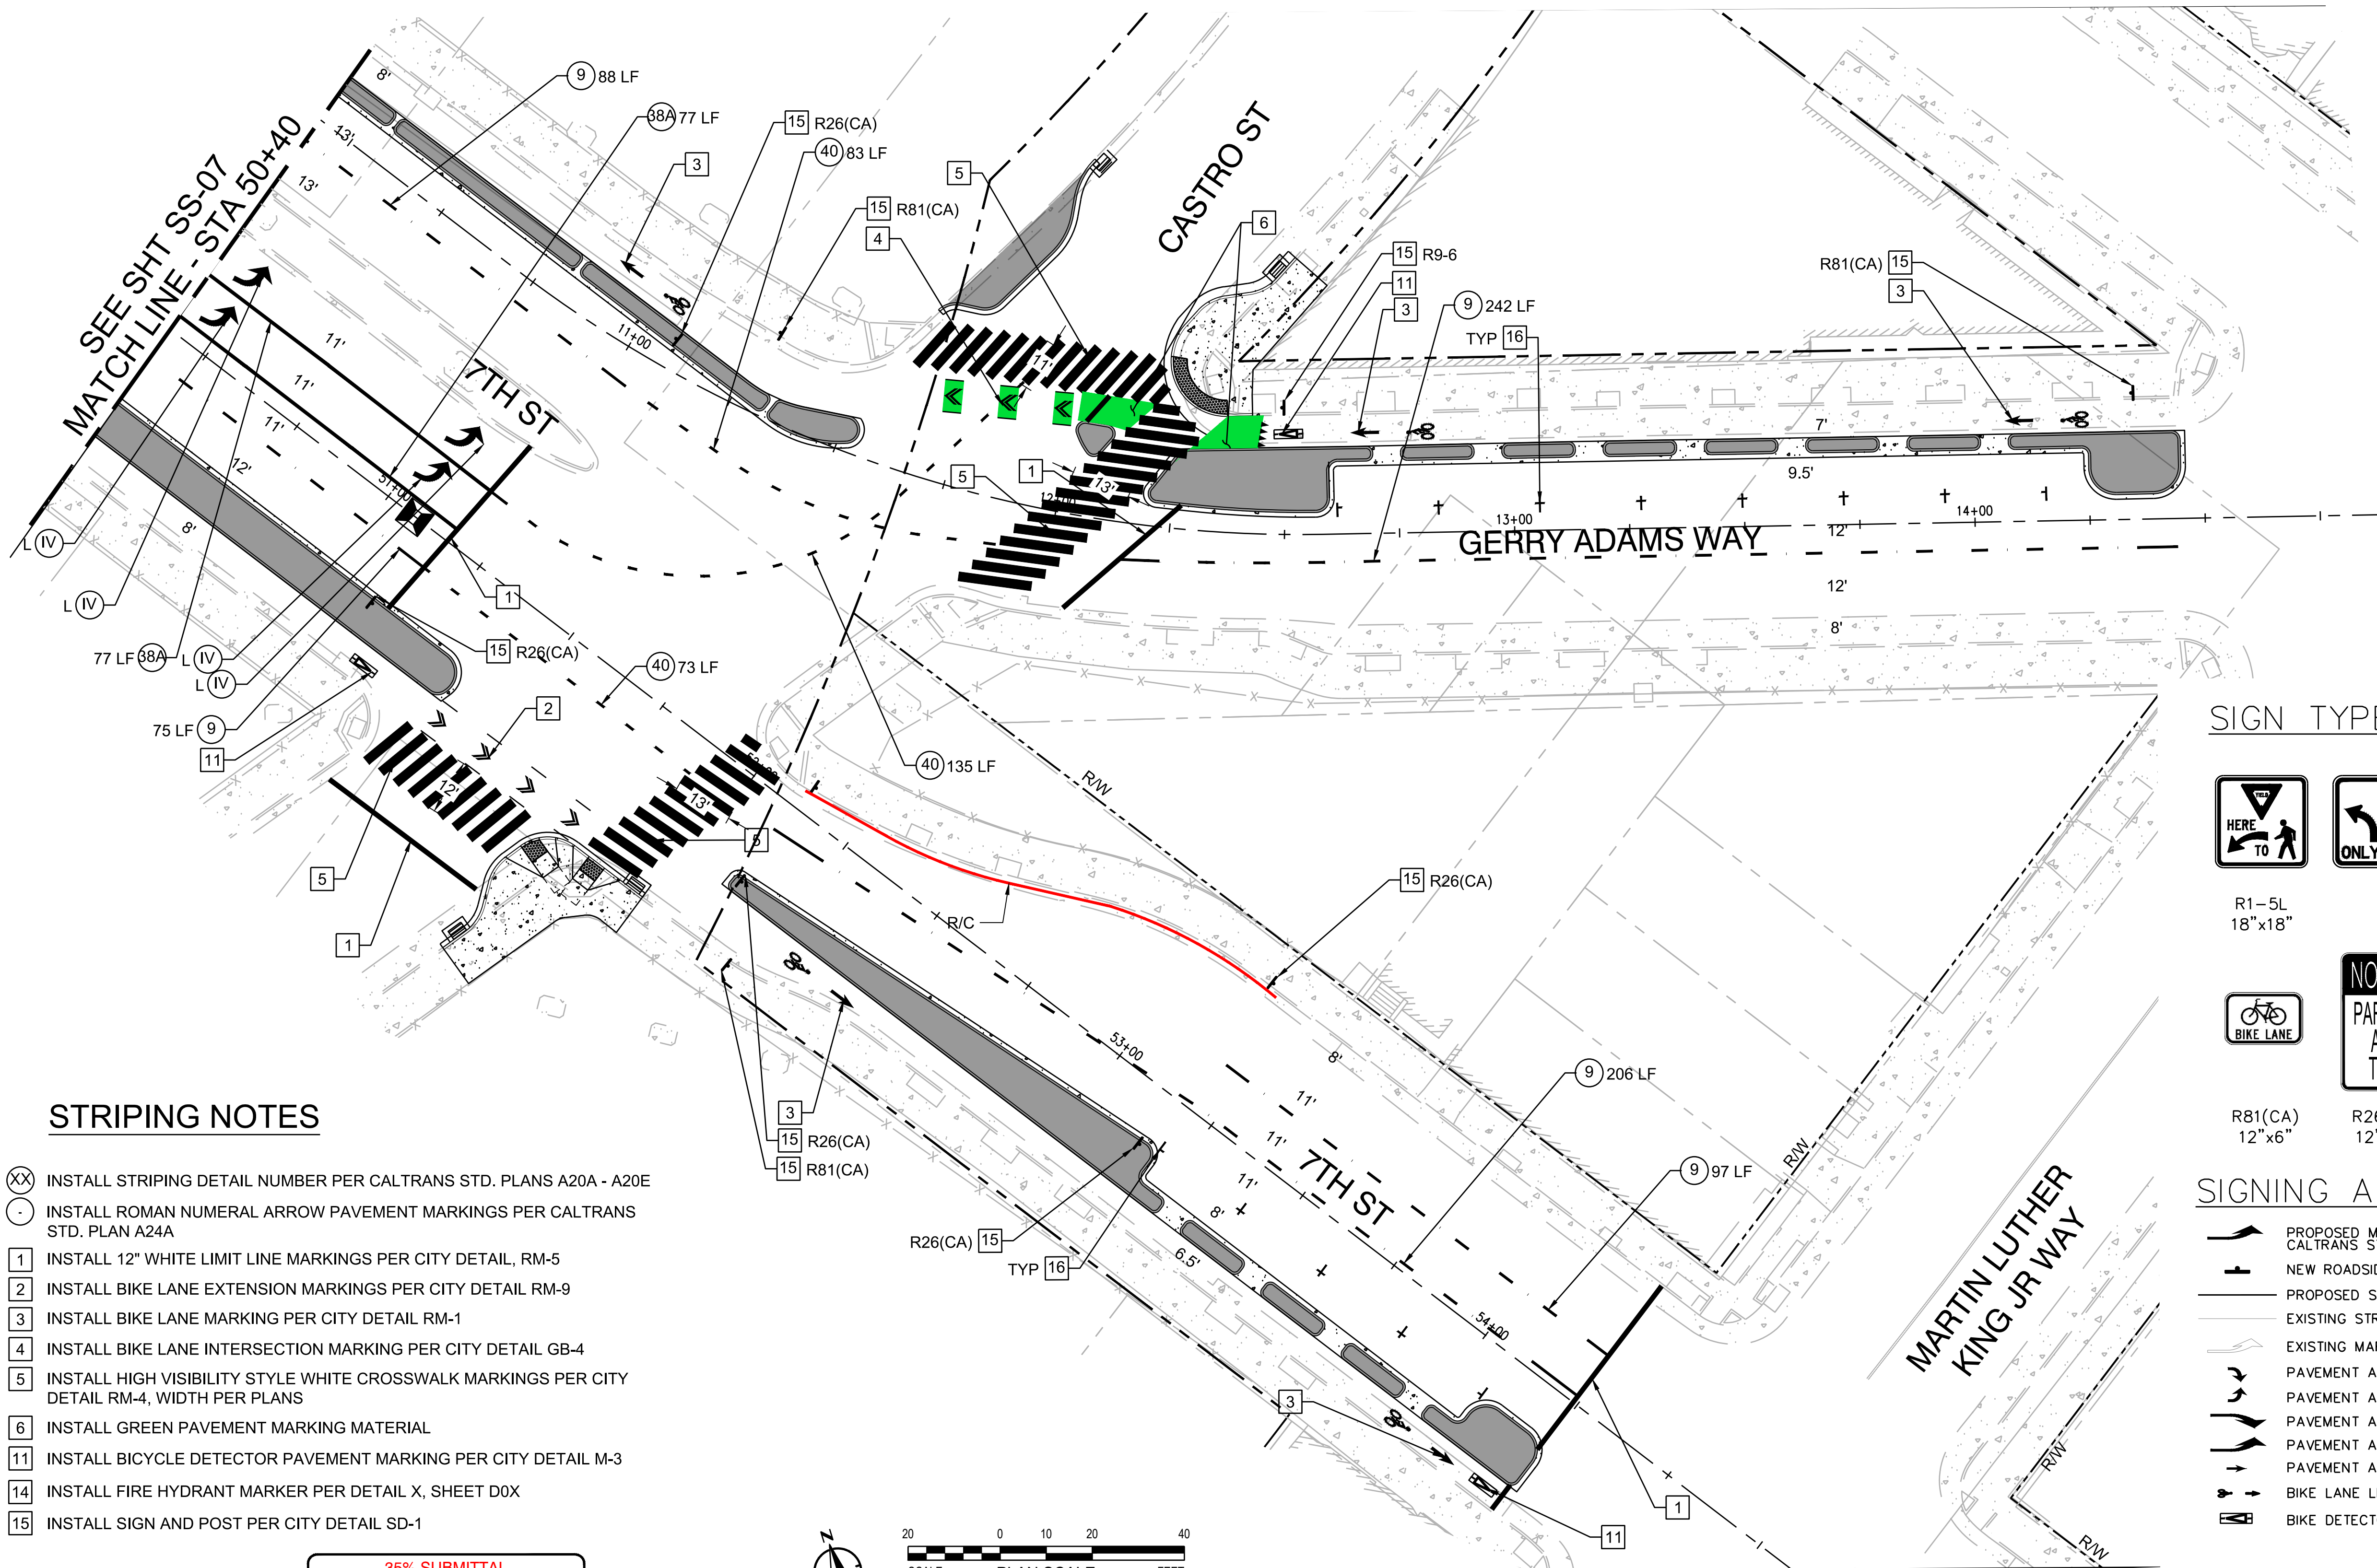

SIGN TYPE LEGEND:

R1-5L 18"x18"	R3-8b 48"x30"	R7-8 12"x18"	R9-6 12"x18"
R81(CA) 12"x6"	R26(CA) 12"x18"	R26(S)(CA) 12"x18"	

SIGNING AND STRIPING LEGEND:


	PROPOSED MARKING PER CALTRANS STANDARD DETAILS		PARKING "T"
	NEW ROADSIDE SIGN ON POLE		YIELD LINE
	PROPOSED STRIPING		WORD SLOW
	EXISTING STRIPING TO REMAIN		WORD SCHOOL
	EXISTING MARKING TO REMAIN		WORD XING
	PAVEMENT ARROW (TYPE IV)		WORD STOP
	PAVEMENT ARROW (TYPE III)		RED CURB PAINT
	PAVEMENT ARROW (TYPE II)		BLUE REFLECTIVE MARKER
	PAVEMENT ARROW (TYPE I, 10')		
	BIKE LANE LEGEND AND ARROW		
	BIKE DETECTOR SYMBOL		

STRIPING NOTES

- XX INSTALL STRIPING DETAIL NUMBER PER CALTRANS STD. PLANS A20A - A20E
- INSTALL ROMAN NUMERAL ARROW PAVEMENT MARKINGS PER CALTRANS STD. PLAN A24A
- 1 INSTALL 12" WHITE LIMIT LINE MARKINGS PER CITY DETAIL, RM-5
- 2 INSTALL BIKE LANE EXTENSION MARKINGS PER CITY DETAIL RM-9
- 3 INSTALL BIKE LANE MARKING PER CITY DETAIL RM-1
- 4 INSTALL BIKE LANE INTERSECTION MARKING PER CITY DETAIL GB-4
- 5 INSTALL HIGH VISIBILITY STYLE WHITE CROSSWALK MARKINGS PER CITY DETAIL RM-4, WIDTH PER PLANS
- 6 INSTALL GREEN PAVEMENT MARKING MATERIAL
- 11 INSTALL BICYCLE DETECTOR PAVEMENT MARKING PER CITY DETAIL M-3
- 14 INSTALL FIRE HYDRANT MARKER PER DETAIL X, SHEET D0X
- 15 INSTALL SIGN AND POST PER CITY DETAIL SD-1

35% SUBMITTAL
NOT FOR BID OR CONSTRUCTION

7TH STREET CONNECTION

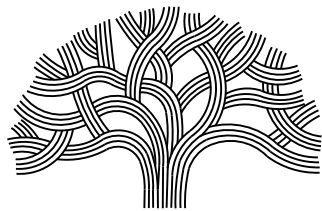

CITY OF OAKLAND

DEPARTMENT OF TRANSPORTATION
250 FRANK H. OGAWA PLAZA, SUITE 4314 * OAKLAND CA, 94612
(510) 238-3437 * FAX (510) 238-7227

CIVIL ENGINEER
THOMAS NATWICK

RCE NO. C78770

CHECKED BY VH

DESIGNED BY MW

DRAWN BY MW

NO.	DATE	BY	REFERENCE

**SIGNING AND STRIPING
PLAN**

BAR IS ONE INCH ON ORIGINAL SIZE SHEET
IF NOT ONE INCH ON THIS SHEET, ADJUST SCALES ACCORDINGLY

ORIGINAL SIZE
ANSI D

PROJECT NO.

1006182

SCALE:

AS SHOWN

DATE:

2/1/2024

SHEET NO.

SS-08

38 OF 46